

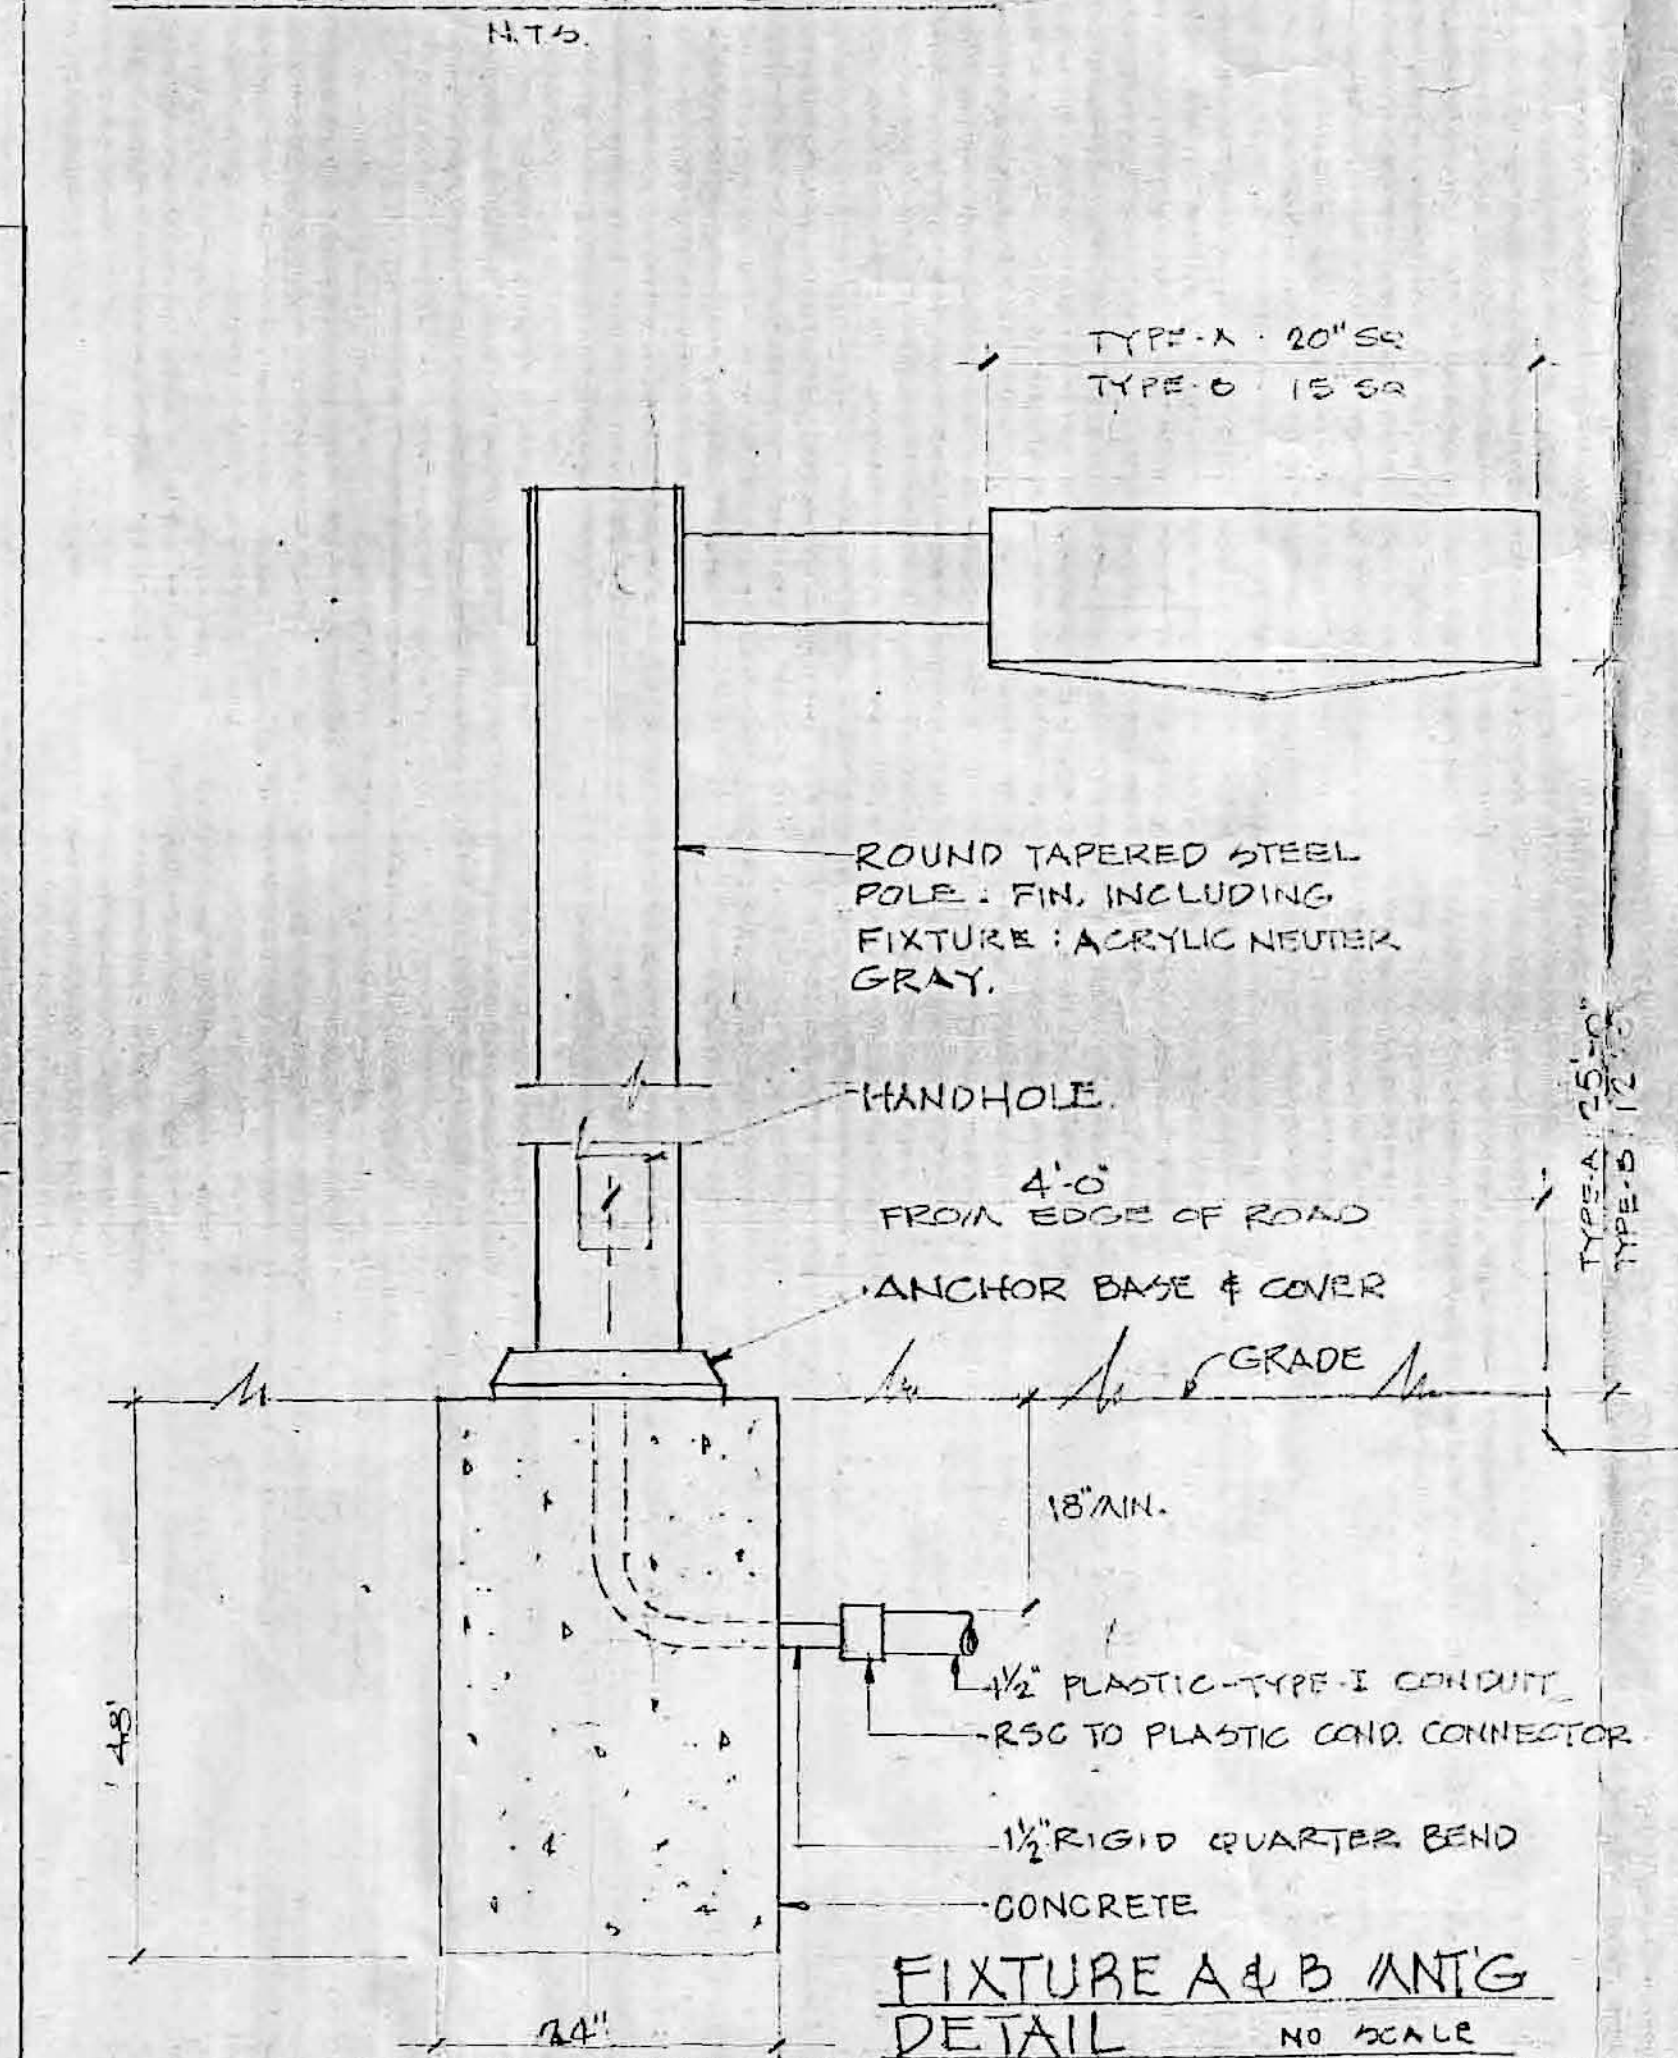
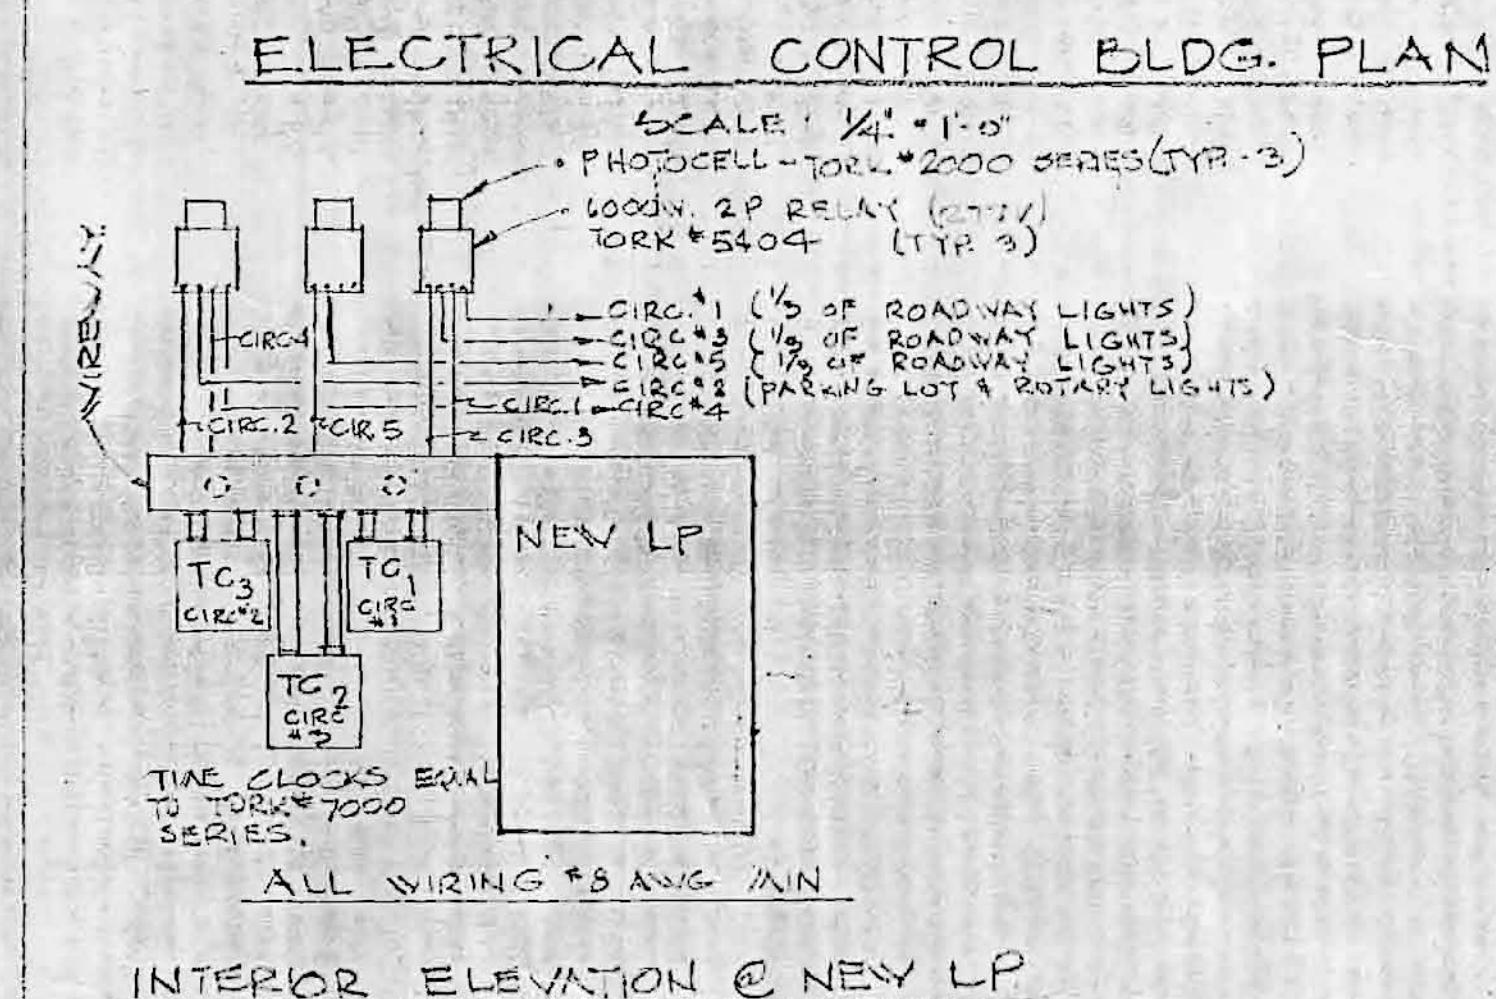


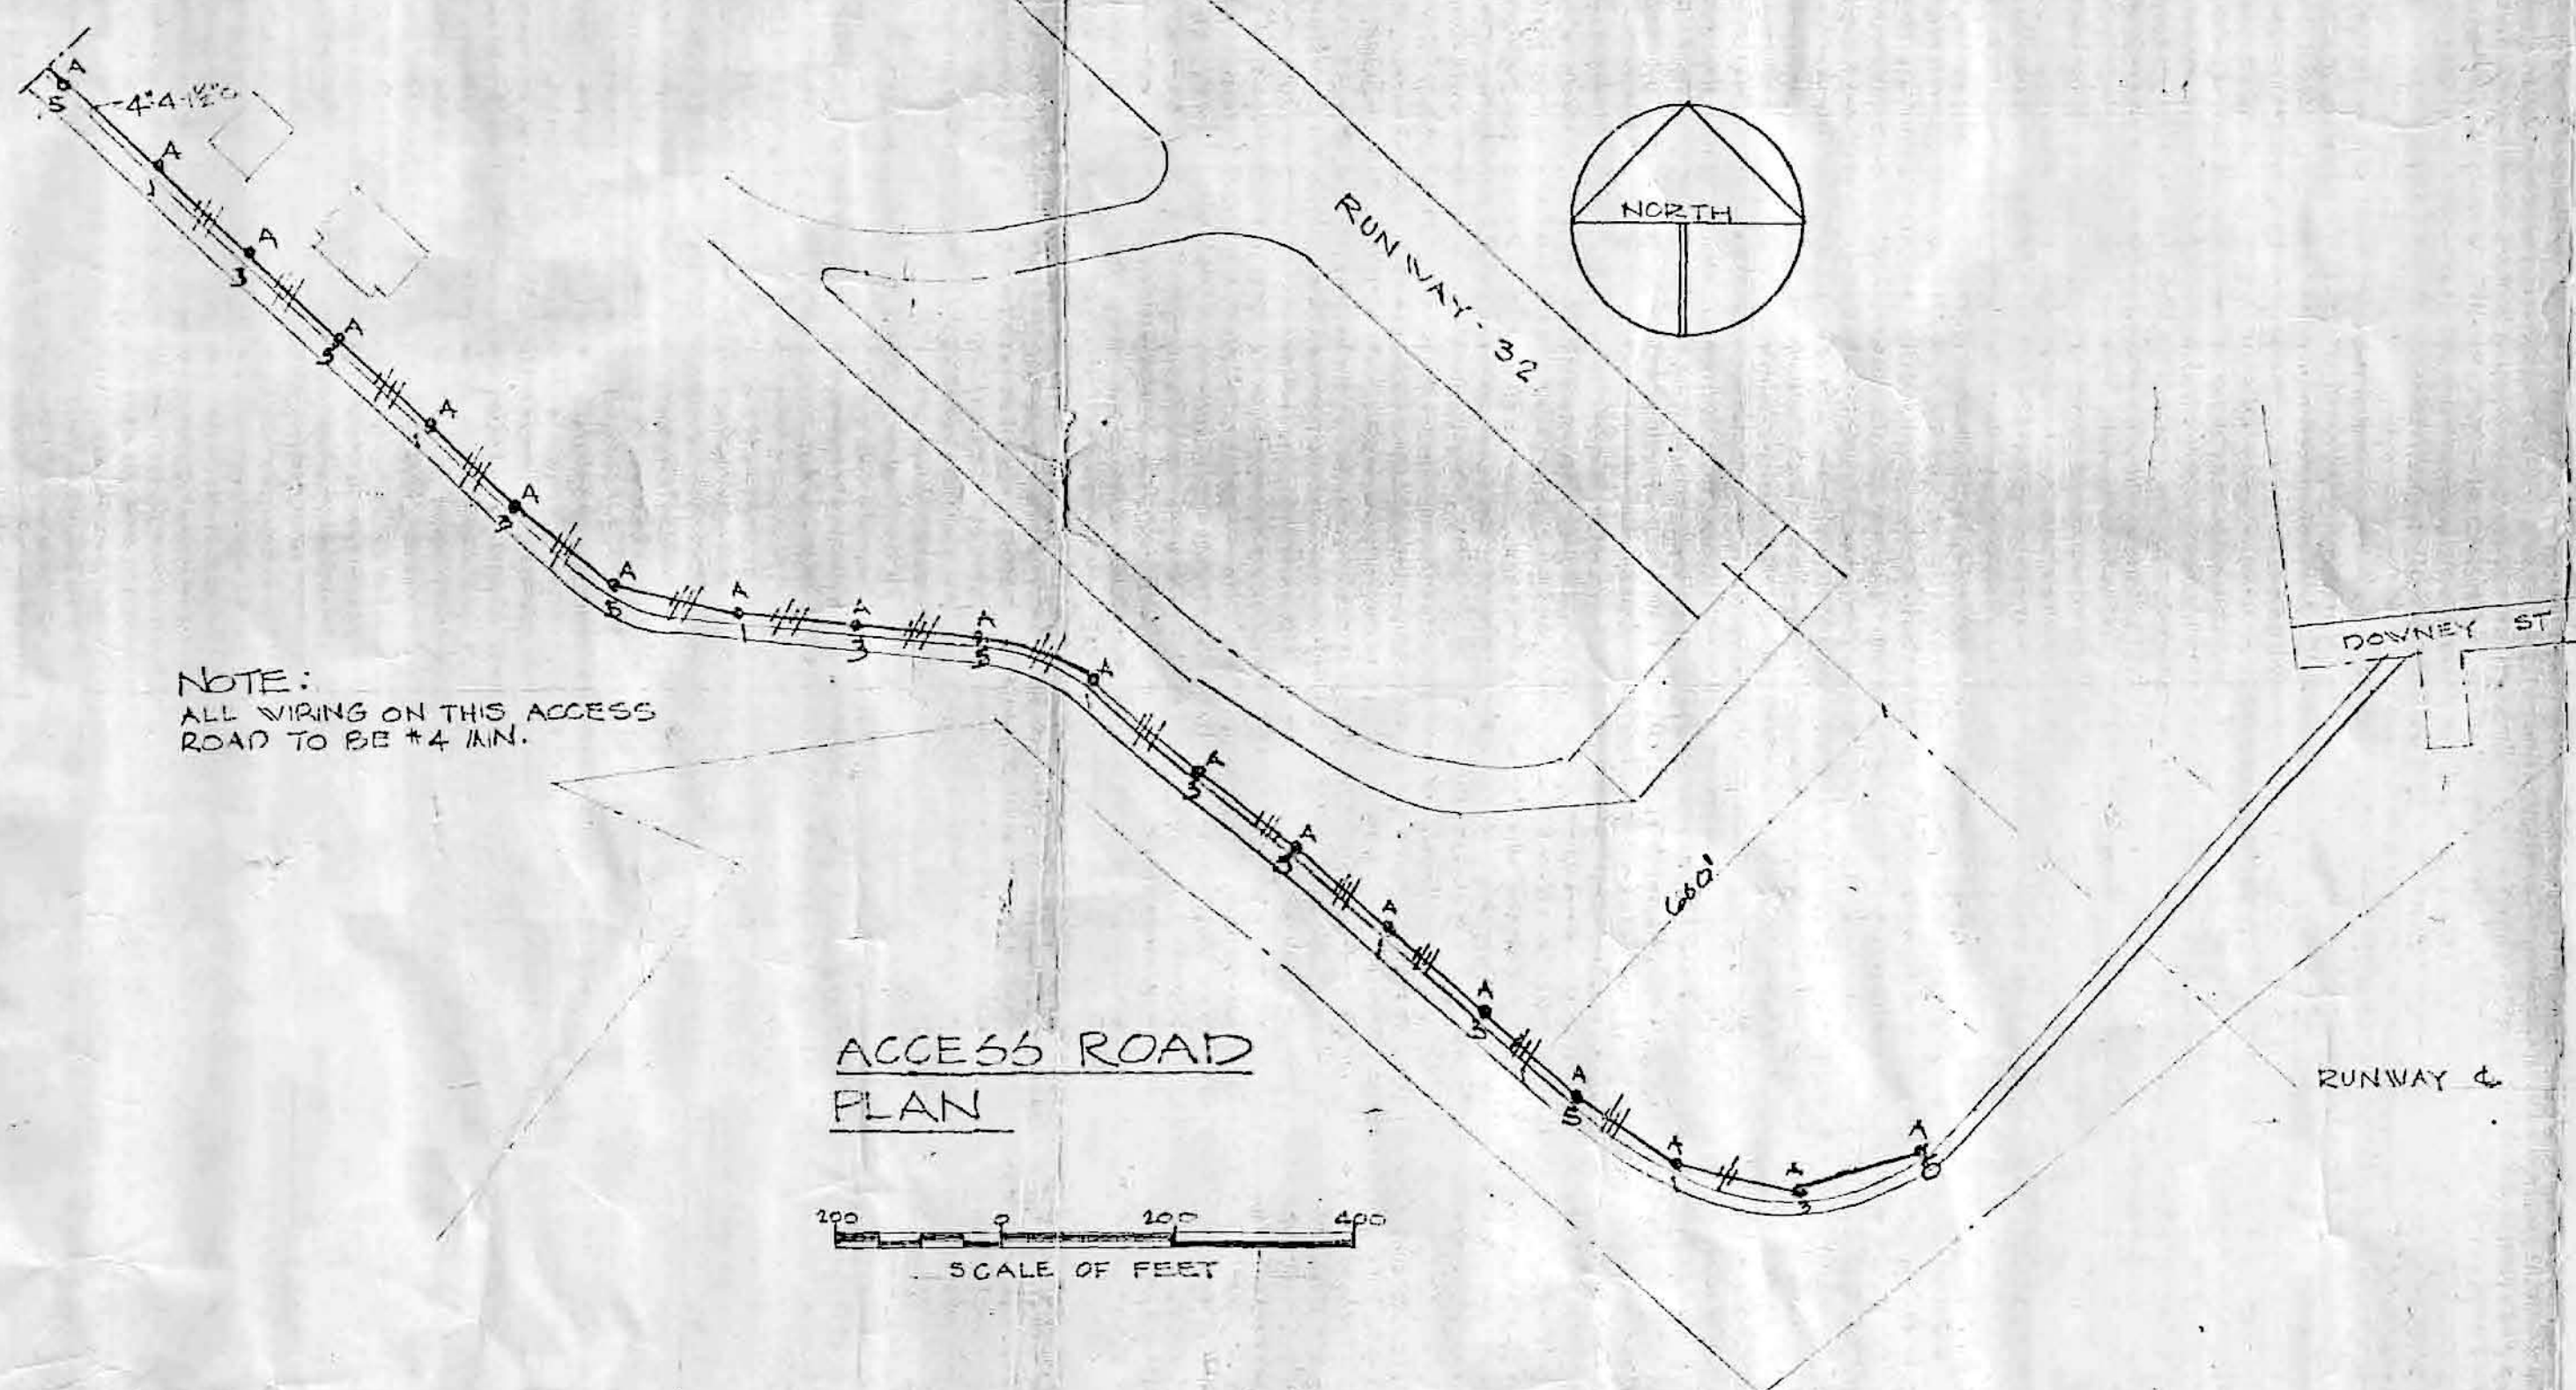

A NEW 25' POLE & POLE AND LUMINAIRE
B NEW 12' POLE & POLE AND LUMINAIRE
EO EXISTING POLE & LUMINAIRE TO BE REMOVED
--- EXISTING UNDERGROUND WIRING TO BE REMOVED
// NEW WIRING 2" - 1" MIN. - NO. OF SLASHES INDICATE
NO. OF WIRES WHEN MORE THAN TWO.

LIGHT FIXTURE SCHEDULE					
TYPE	MANUFACTURER'S CAT. NO.	No.	LAMP		REMARKS
			TYPE	WATT.	
A	PRESCOLITE CL120-415-RST-25	277	HPS 400 W 2500 K	250	
B	PRESCOLITE CL115-417-RST-12	277	"	100	

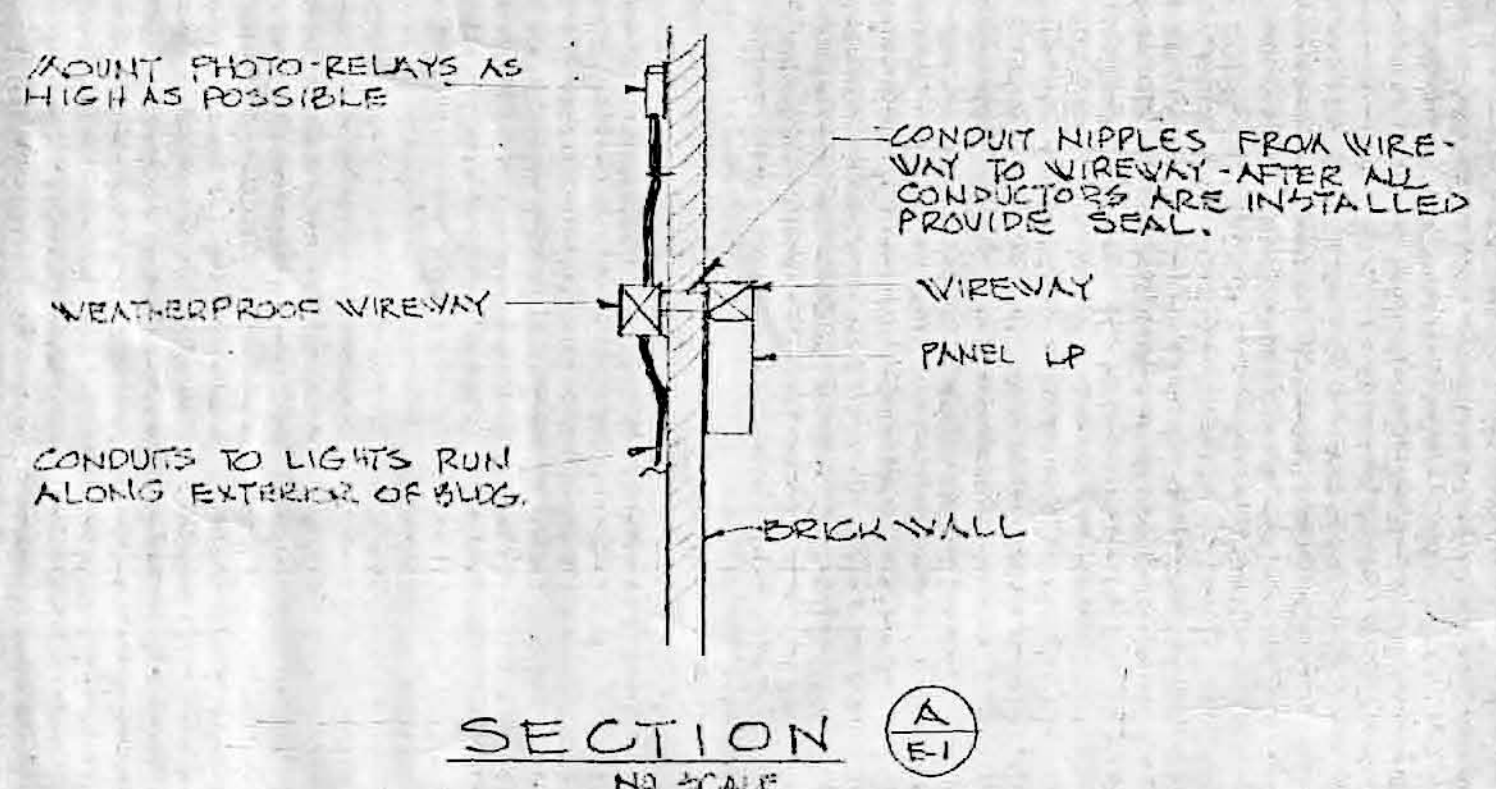

DATE	REVISIONS	
COMMUNITY DEVELOPMENT PROJECT B-51 NEW BEDFORD, MASSACHUSETTS		
AIRPORT IMPROVEMENTS NEW BEDFORD MUNICIPAL AIRPORT		SCALE AS NOTED DATE 3-17-77 DRAWN BY RLL
R. LEBLANC CO. NEW BEDFORD, MASS.		DRAWING NO. E-1