




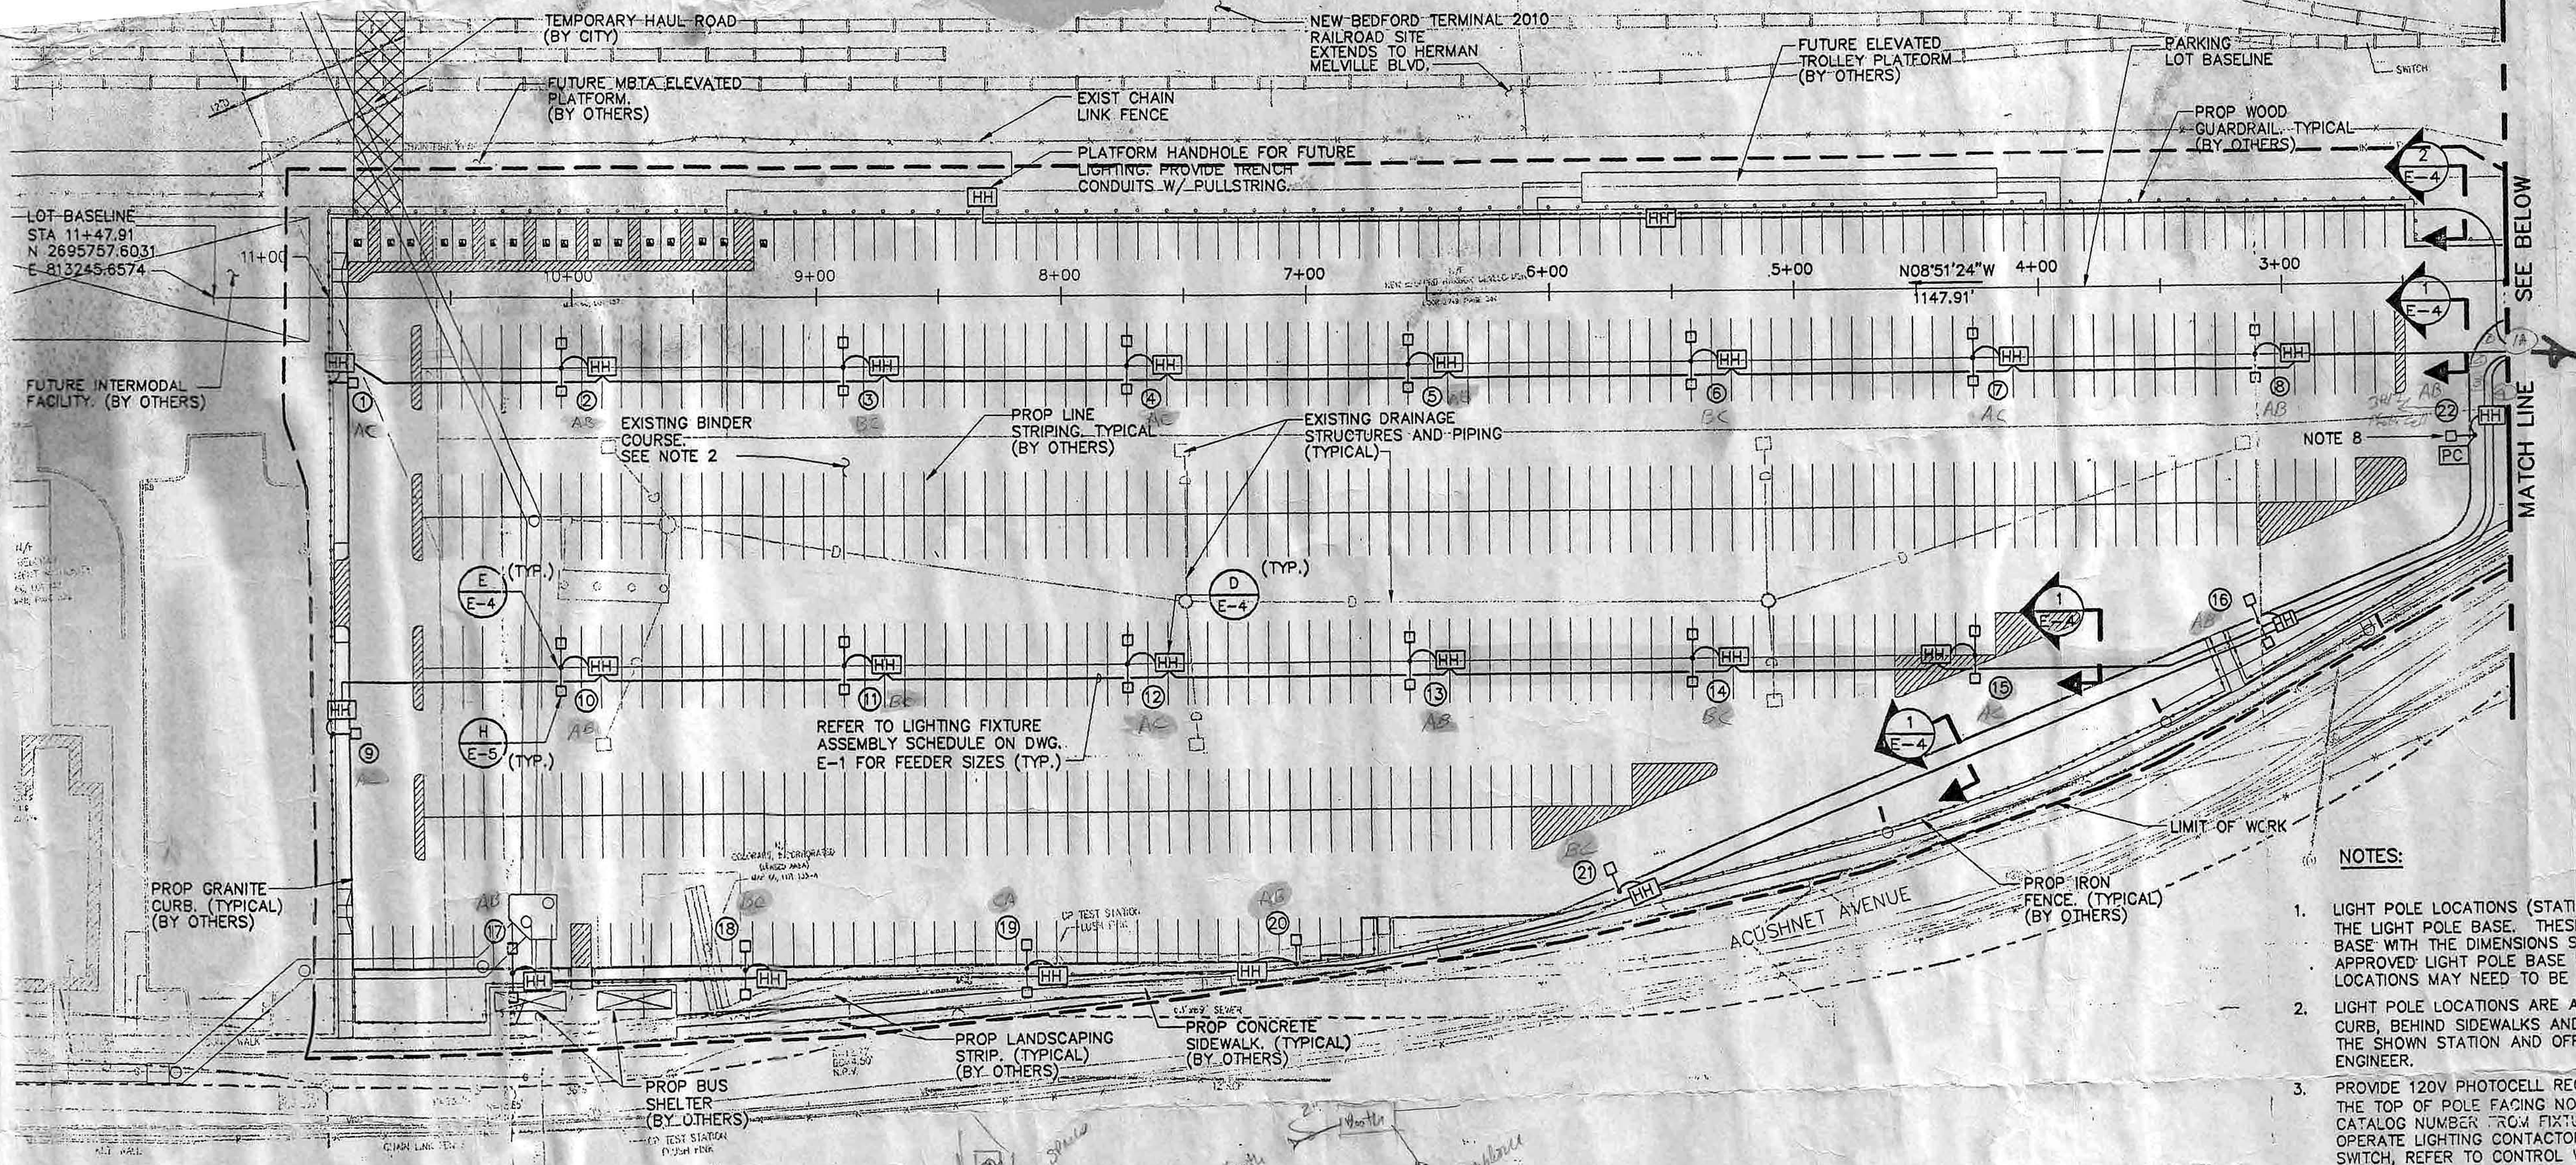


NOTES:

1. LIGHT POLE LOCATIONS (STATION AND OFFSET) ARE TAKEN AT THE CENTER OF THE LIGHT POLE BASE. THESE LOCATIONS WERE BASED ON A LIGHT POLE BASE WITH THE DIMENSIONS SHOWN ON SHEET E-4. IF THE SUBMITTED AND APPROVED LIGHT POLE BASE HAS DIFFERENT DIMENSIONS THAN SHOWN, THE LOCATIONS MAY NEED TO BE ADJUSTED.
2. LIGHT POLE LOCATIONS ARE AT INTERSECTIONS OF PARKING SPACES, BEHIND CURB, BEHIND SIDEWALKS AND BEHIND GUARDRAIL. ANY RELOCATION FROM THE SHOWN STATION AND OFFSET WILL NEED TO BE COORDINATED WITH THE ENGINEER.
3. PROVIDE 120V PHOTOCELL RECEPTACLE W/ LUMINAIRE & PHOTOCELL MOUNTED THE TOP OF POLE FACING NORTH. ADD SUFFIX (A-25) TO SINGLE LUMINAIRE CATALOG NUMBER FROM FIXTURE ASSEMBLY SCHEDULE. PHOTOCELL SHALL OPERATE LIGHTING CONTACTOR IN CONJUNCTION WITH TIMECLOCK & SELECTOR SWITCH, REFER TO CONTROL WIRING DETAIL ON DWG. E-5.
4. ELECTRIC SERVICE CONNECTION REFER TO ONE-LINE DIAGRAM ON DWG. E-3 FOR ADDITIONAL INFORMATION.
5. TELEPHONE SERVICE CONNECTION. 2" CONDUIT AND 2" SPARE CONDUIT FROM EXISTING VERIZON UNDERGROUND CONDUIT AND NEW VERIZON INSTALLED HANDHOLE TO FARE COLLECTION BOOTH BACKBOARD. ALL WORK SHALL BE COORDINATED WITH VERIZON.

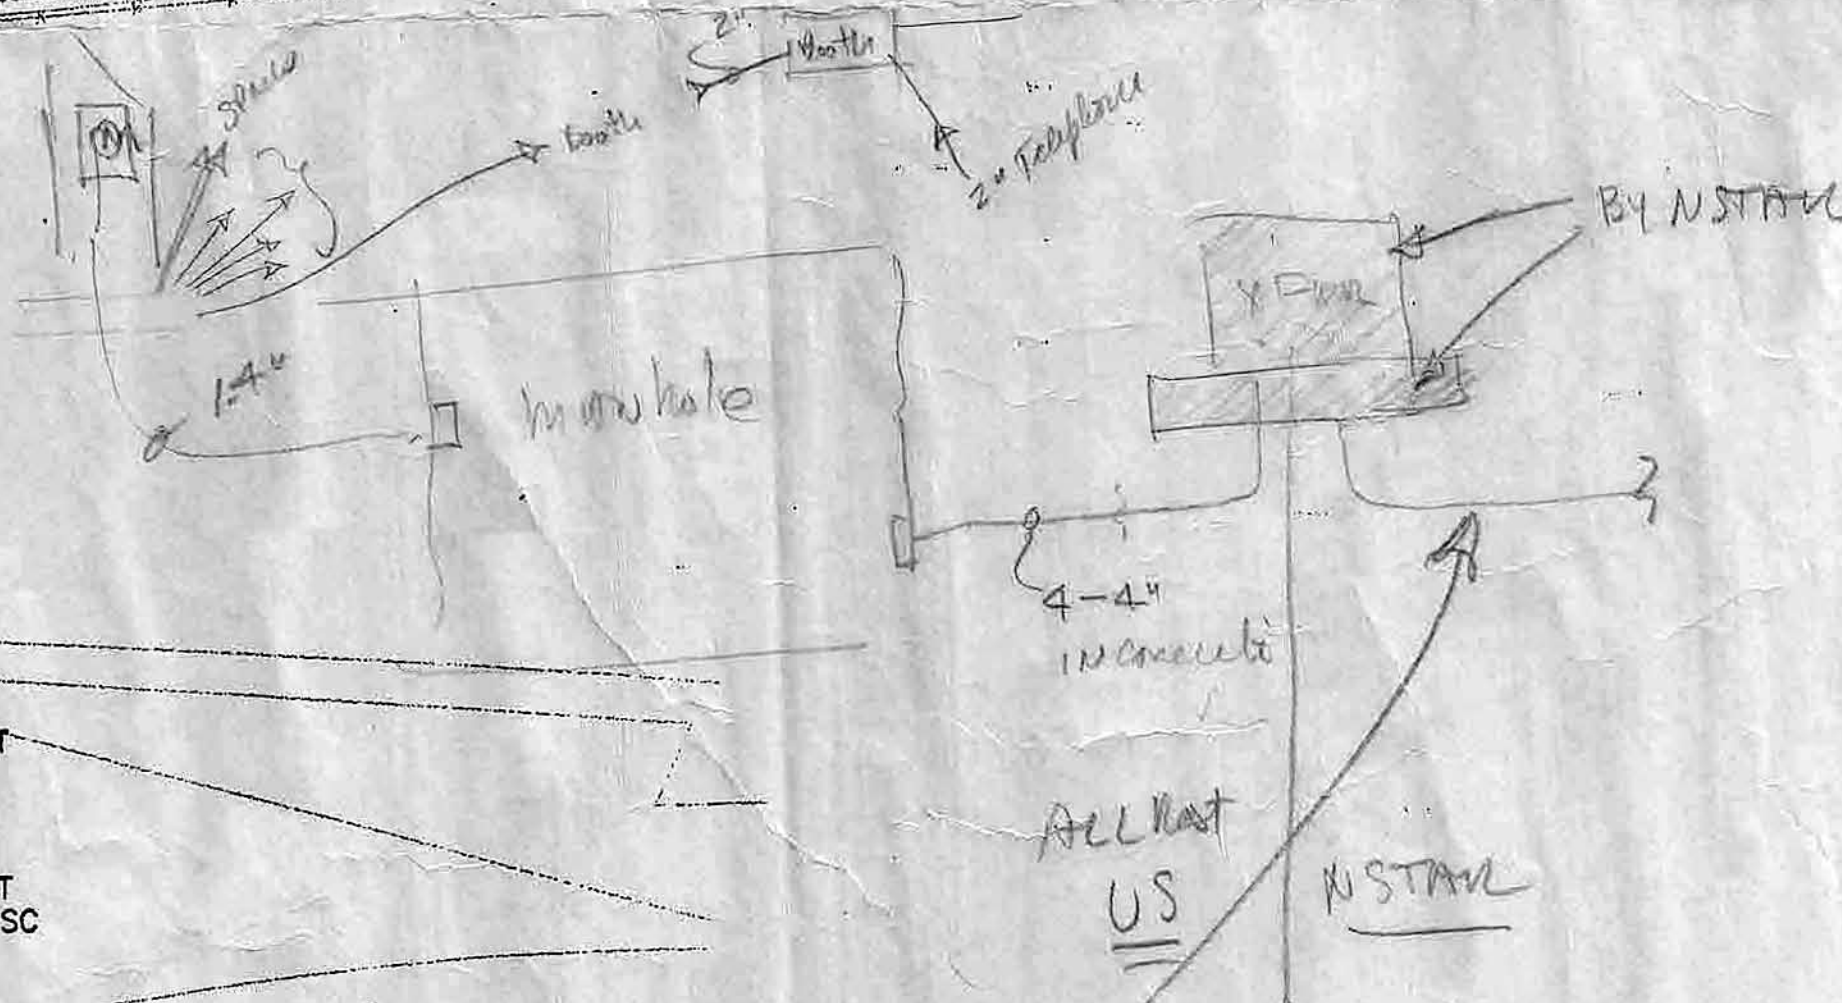

REVISED

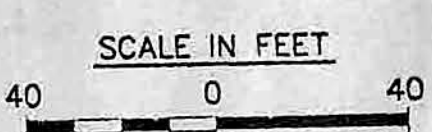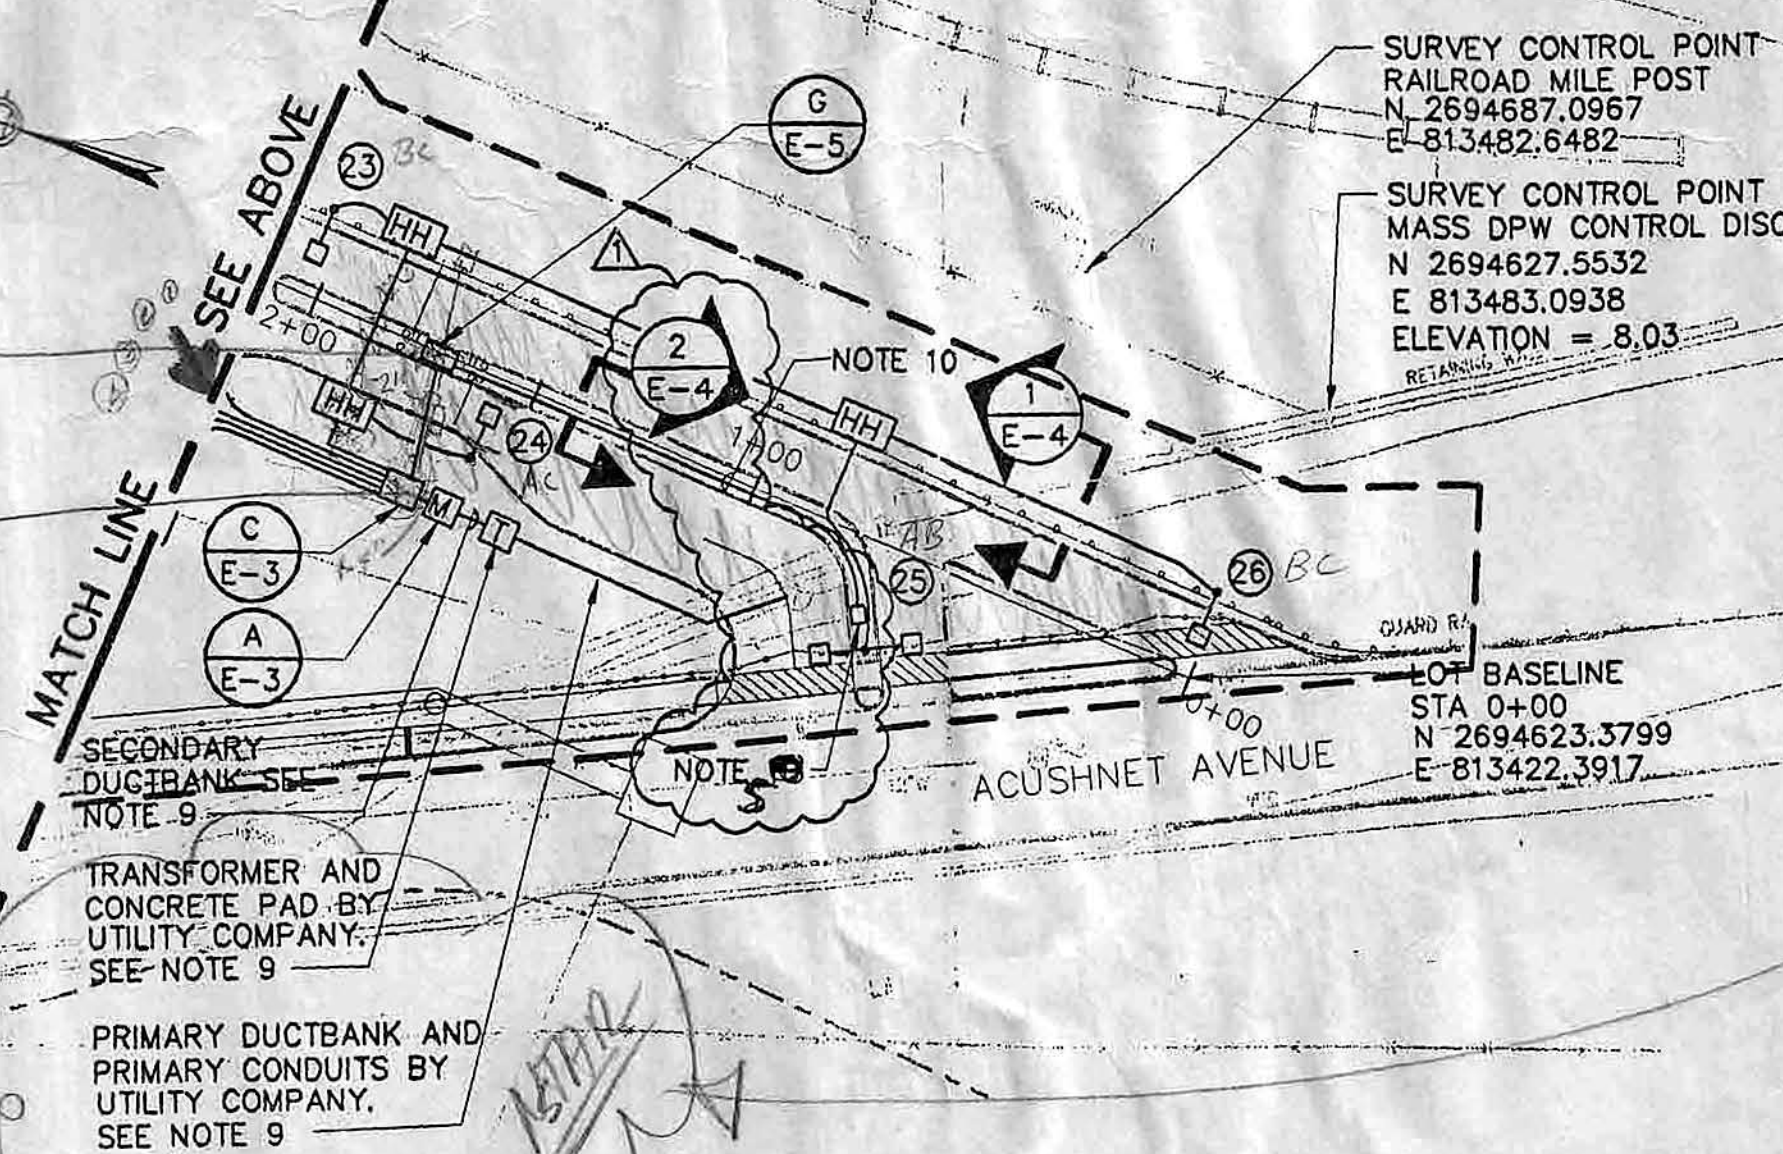

ISSUE DATE	DESCRIPTION	BY	CHKD	APP
	SPARE TELEPHONE CONDUIT ADDED	CM	MC	PK

CITY OF NEW BEDFORD, MASS.		SHEET 1 OF 2	
RAIL YARD CSO RELOCATION PROJECT WITH PARKING			
CHANGE ORDER NO 2 - WHALES			
ELECTRICAL PLAN			
STV Incorporated 321 Summer Street Boston, MA 02210		PROJECT MANAGER	
SCALE: 1" = 40'-0"	DRAWN BY: WD	CHECK BY: MC	PLAN NO. SHEET E-2
DATE: 10-03-03	WD	MC	PK

Revised