


NOTES:

1. FOR GENERAL NOTES, LEGEND, ABBREVIATIONS AND DETAILS REFER TO SHEET 64.
2. #LC1 IS LOCATED IN NEW LANDSCAPE AREA, SEE LANDSCAPE PLAN 1.

RECORD SET.

CITY OF NEW BEDFORD ROUTE 18 RECONSTRUCTION			
STATE	FED. AID PROJ. NO.	SHEET NO.	TOTAL SHEETS
MASS.	HP-0029(145)	65	161
PROJECT FILE NO.		602857	

LIGHTING PLAN - 1

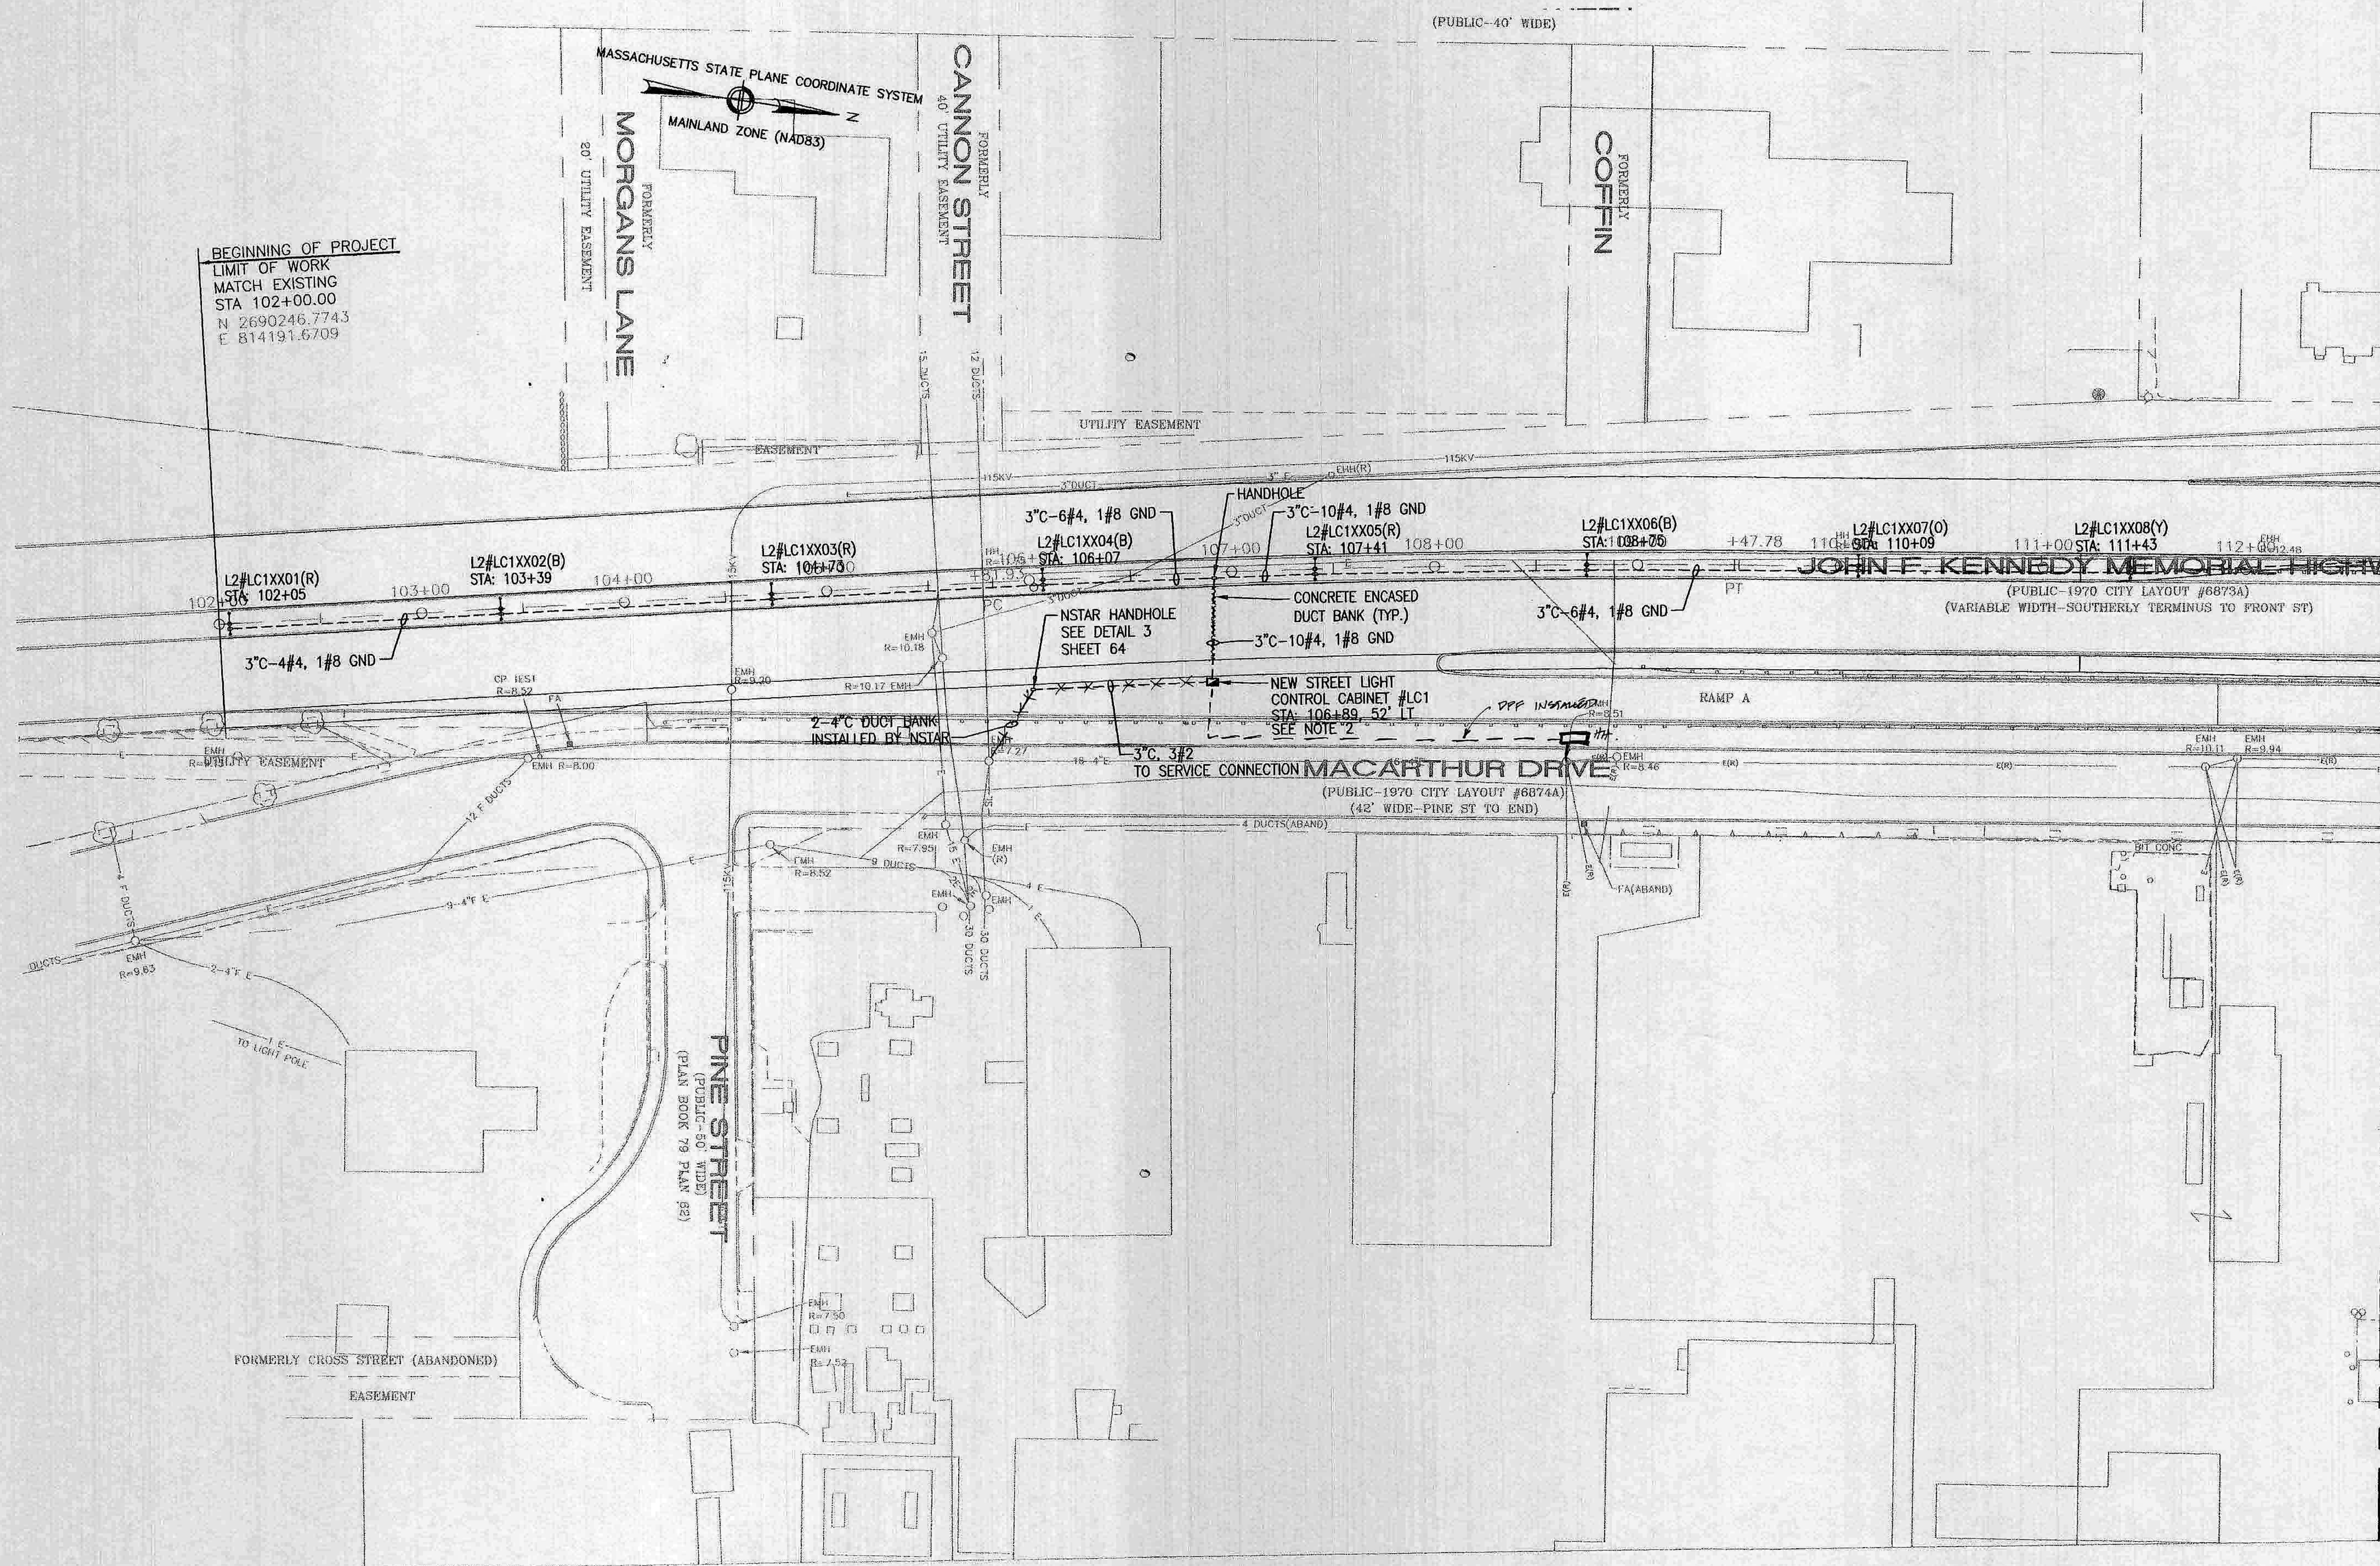

MATCHLINE STA 112+70
FOR CONTINUATION SEE SHEET 66