


EVERSOURCE ENERGY

INDEPENDENT STREET MAIN RELAY
INSTALLATION OF 715' OF 2" PH LIP GAS MAIN
INDEPENDENT STREET
NEW BEDFORD, MASSACHUSETTS
ENE PROJECT #: 2005881.43
EVERSOURCE PROJECT #: 4129985



LOCUS PLAN
NOT TO SCALE

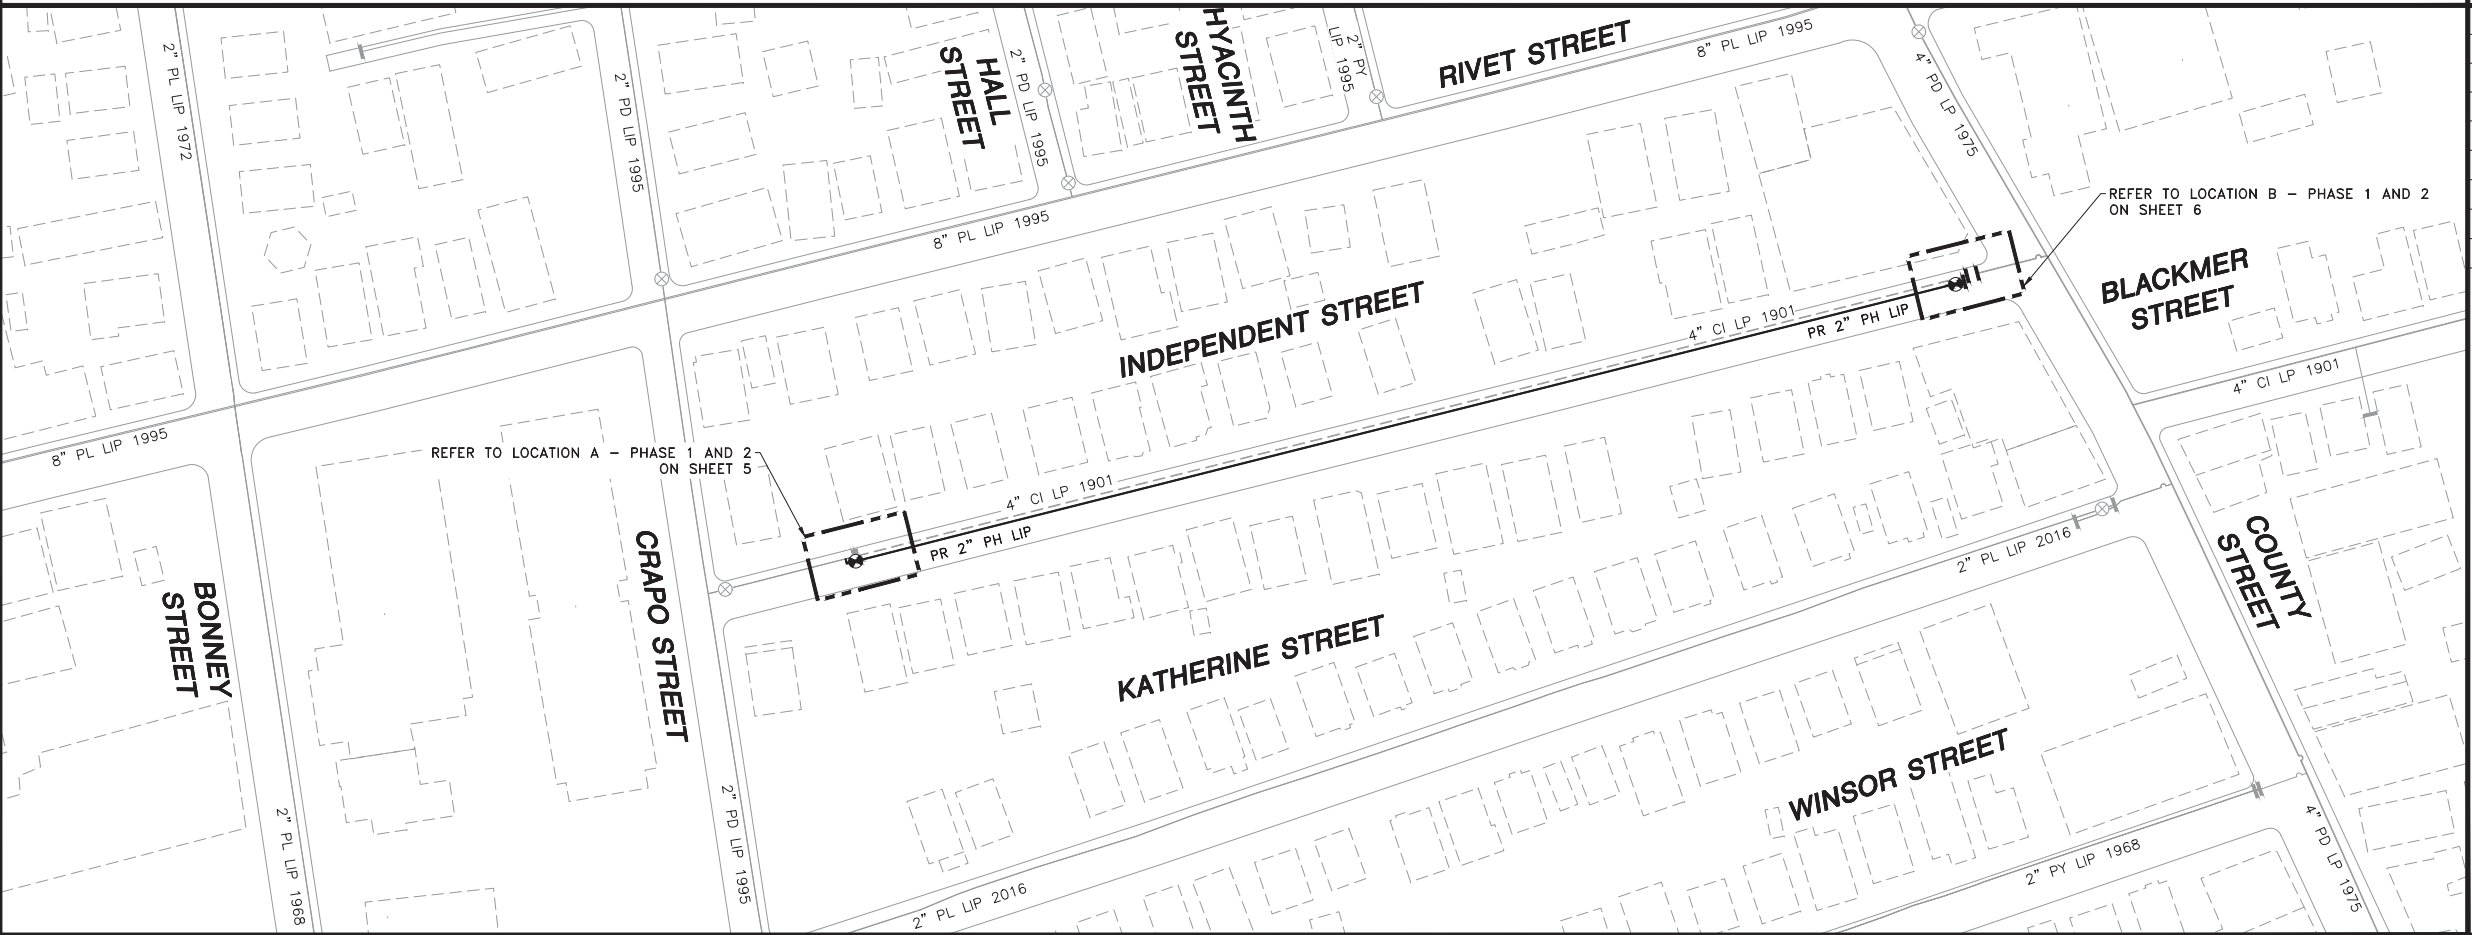

NOTE:
EXISTING CONDITIONS SHOWN ARE BASED ON GIS, AERIAL AND AVAILABLE RECORD DATA.
NO FIELD SURVEY WAS PERFORMED. CONTRACTOR TO VERIFY EXISTING CONDITIONS AS
NEEDED IN THE FIELD. PROPOSED MAIN ALIGNMENT AND OFFSETS ARE APPROXIMATE.

SITE PLAN
NEW BEDFORD, MASSACHUSETTS
(SCALE: 1"=60')
(DO NOT SCALE FROM DRAWINGS)

0	ISSUED FOR CONSTRUCTION	01/11/2021	RT/AB/EK
NO.	DESCRIPTION	DATE	DW/CK/AP

REVISION STATUS

EVERSOURCE
ENERGY

INDEPENDENT STREET MAIN RELAY
NEW BEDFORD, MASSACHUSETTS

SITE PLAN, LOCUS PLAN AND SHEET INDEX

SCALE: AS NOTED		SHEET 1 OF 7	
DRAWN BY / DATE KT 10/19/2020	CHECKED BY / DATE AB 01/11/2021	SHEET NUMBER MA-NEB-21-PIP-010-01	REV. NO. 0
APPROVED BY / DATE EK 01/11/2021	MANEB21PIP010R0		

ISSUED FOR
CONSTRUCTION
01/11/2021

SEALED BY:



SIGNATURE

SEALED ON:

01/11/2021

LICENSE
EXPIRATION:



06/30/2022

DESIGNED IN ACCORDANCE WITH TITLE
49, PART 192 OF MINIMUM FEDERAL SAFETY
STANDARDS AND GPTC GUIDE FOR GAS
TRANSMISSION AND DISTRIBUTION PIPING
SYSTEMS, LATEST EDITION.

ENEngineering

29 BARTLETT STREET
MARLBOROUGH, MA 01752
TEL (603) 353-4000
FAX (603) 335-7777
WWW.ENENGINEERING.COM

FIELD VERIFY DIMENSIONS
PRIOR TO PIPE FABRICATION

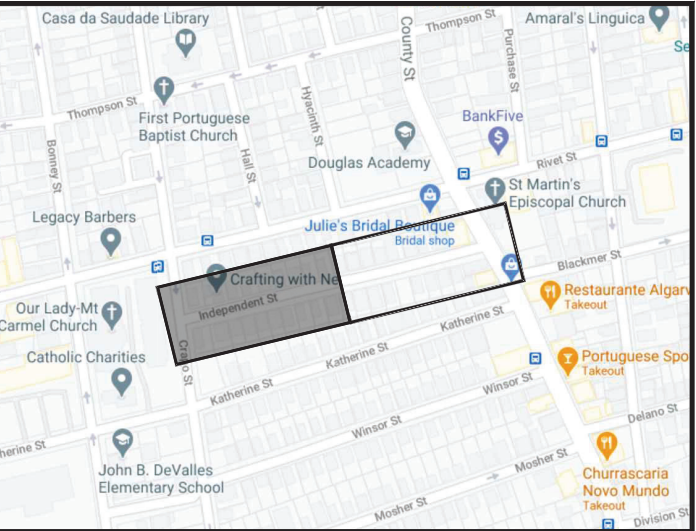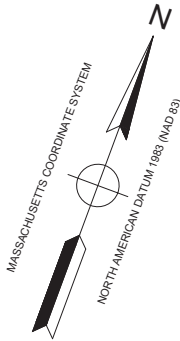

DRAWING LEGEND

	UTILITY POLE		EXISTING GAS MAIN
	LIGHT POLE		RETIRED GAS MAIN
	CATCH BASIN		PROPOSED GAS MAIN
	FIRE HYDRANT		EXISTING SERVICE
	UTILITY MANHOLE		RIGHT OF WAY
	ELECTRIC MANHOLE		ELECTRIC
	TELEPHONE MANHOLE		TELEPHONE
	WATER MANHOLE		WATER
	SANITARY MANHOLE		SANITARY SEWER
	STORM MANHOLE		STORM SEWER
	EXISTING REDUCER		PROPOSED REDUCER
	EXISTING CAP		PROPOSED CAP
	EXISTING VALVE		PROPOSED VALVE
	EXISTING COUPLING		PROPOSED ANODE

0	ISSUED FOR CONSTRUCTION	01/11/2021	RT/AB/EK
NO.	DESCRIPTION	DATE	DW/CK/AP

REVISION STATUS


EVERSOURCE
ENERGY

INDEPENDENT STREET MAIN RELAY
NEW BEDFORD, MASSACHUSETTS

INSTALLATION PLAN

SCALE: 1"=20' (DO NOT SCALE FROM DRAWINGS)		SHEET 3 OF 7	
DRAWN BY / DATE KT 10/19/2020	CHECKED BY / DATE AB 01/11/2021	SHEET NUMBER MA-NEB-21-PIP-010-03	REV. NO. 0
APPROVED BY / DATE EK 01/11/2021		MANEB21PIP010R0	

INDEPENDENT STREET

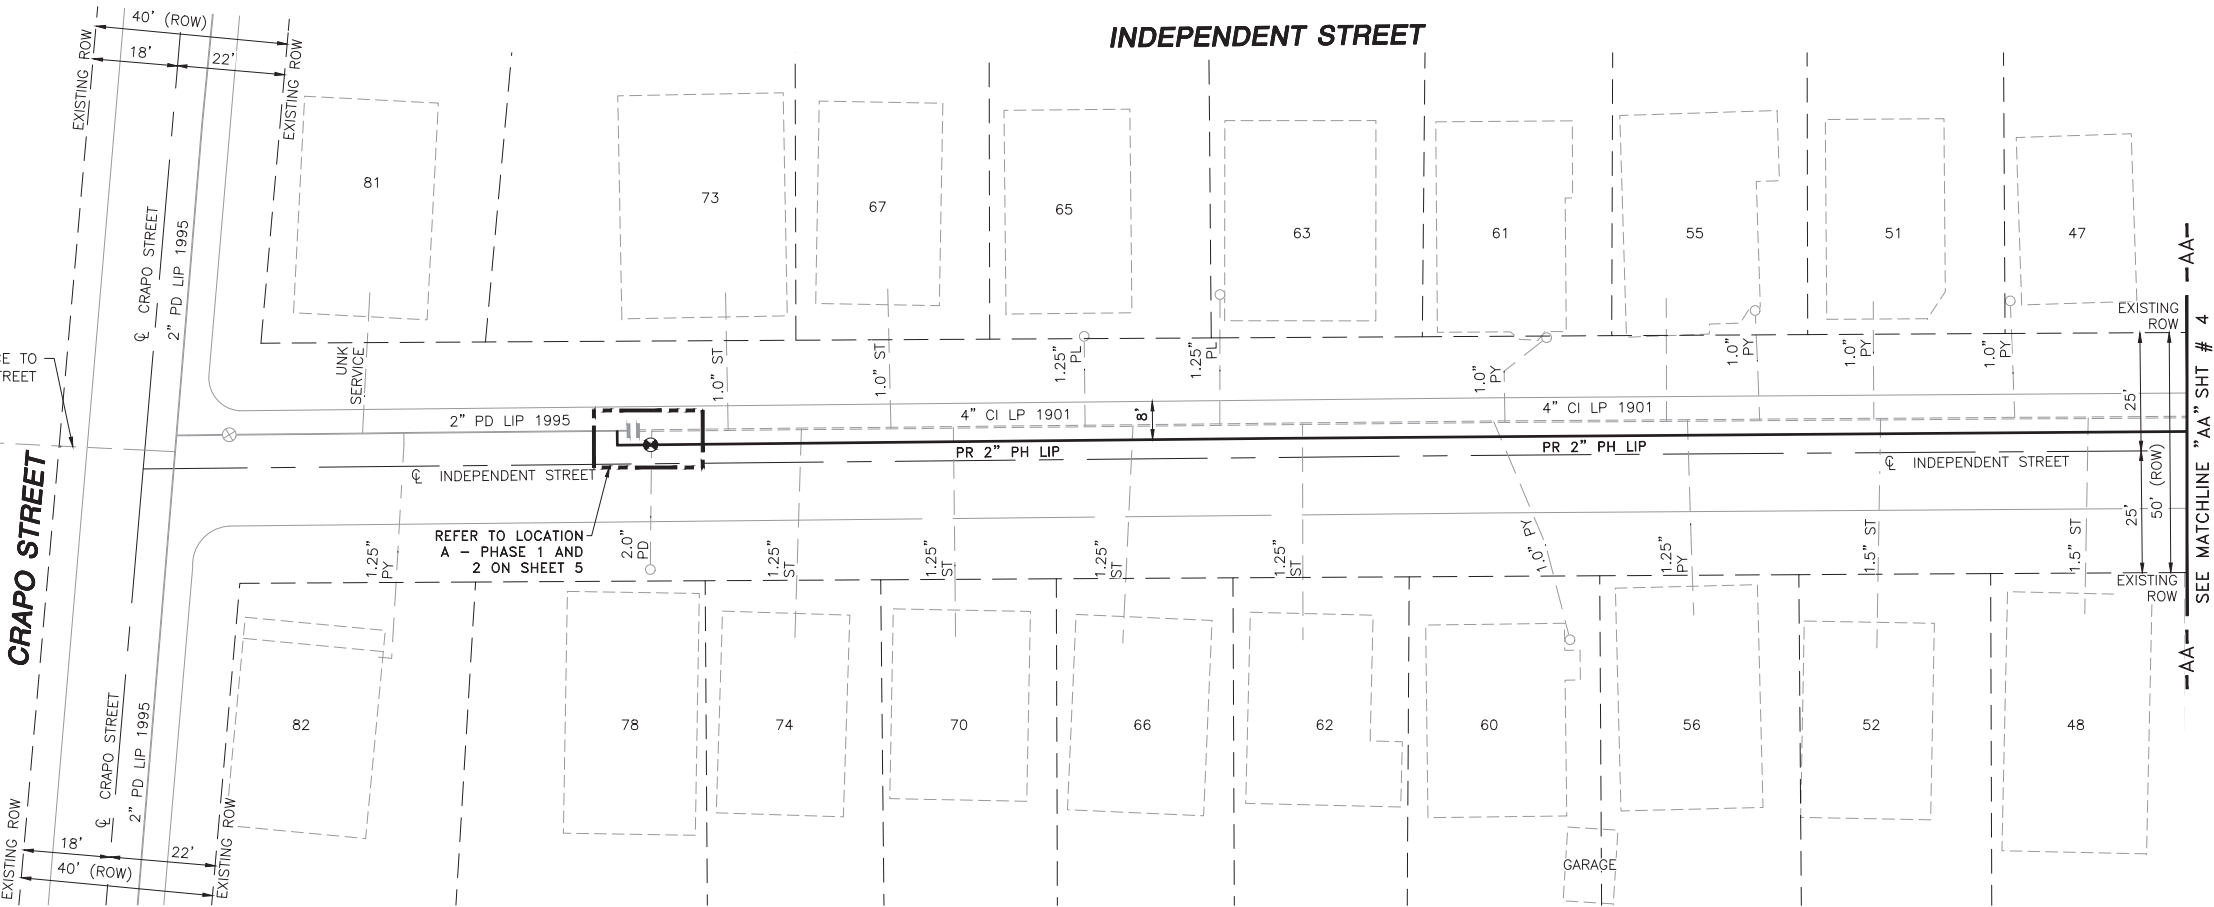

- NOTES:
- CONTRACTOR TO POTHOLE EXISTING UTILITIES AT CROSSING LOCATIONS PRIOR TO CONSTRUCTION.
 - REFER TO GENERAL NOTES AND SCHEDULE OF MATERIALS ON SHEET #2.

LENGTH	SIZE	MATERIAL	DESCRIPTION
330'	2"	PH	INSTALL
325'	4"	CI	RETIRE

ISSUED FOR
CONSTRUCTION
01/11/2021

SEALED BY:



SIGNATURE

SEALED ON:

01/11/2021

LICENSE EXPIRATION:


06/30/2022

DESIGNED IN ACCORDANCE WITH TITLE 49, PART 192 OF MINIMUM FEDERAL SAFETY STANDARDS AND GPTC GUIDE FOR GAS TRANSMISSION AND DISTRIBUTION PIPING SYSTEMS, LATEST EDITION.



ENEngineering

29 BARTLETT STREET
MARLBOROUGH, MA 01752
TEL (630) 353-4000
FAX (630) 535-7777
WWW.ENENGINEERING.COM

FIELD VERIFY DIMENSIONS
PRIOR TO PIPE FABRICATION

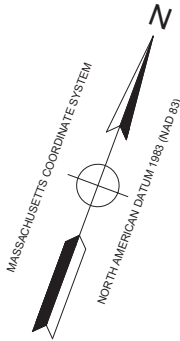

INDEPENDENT STREET

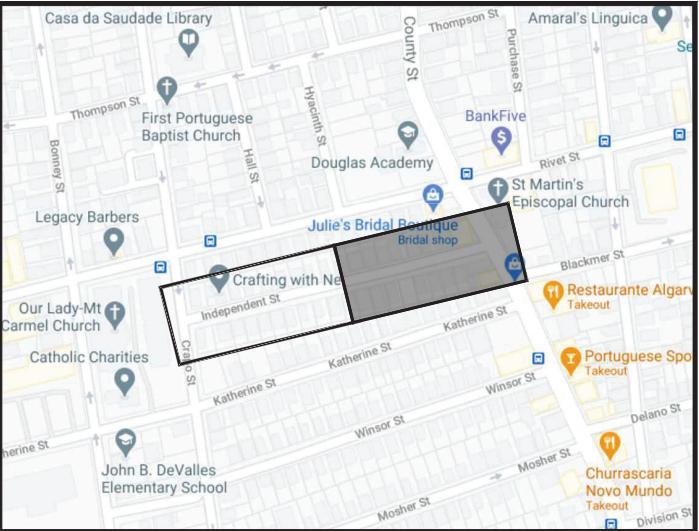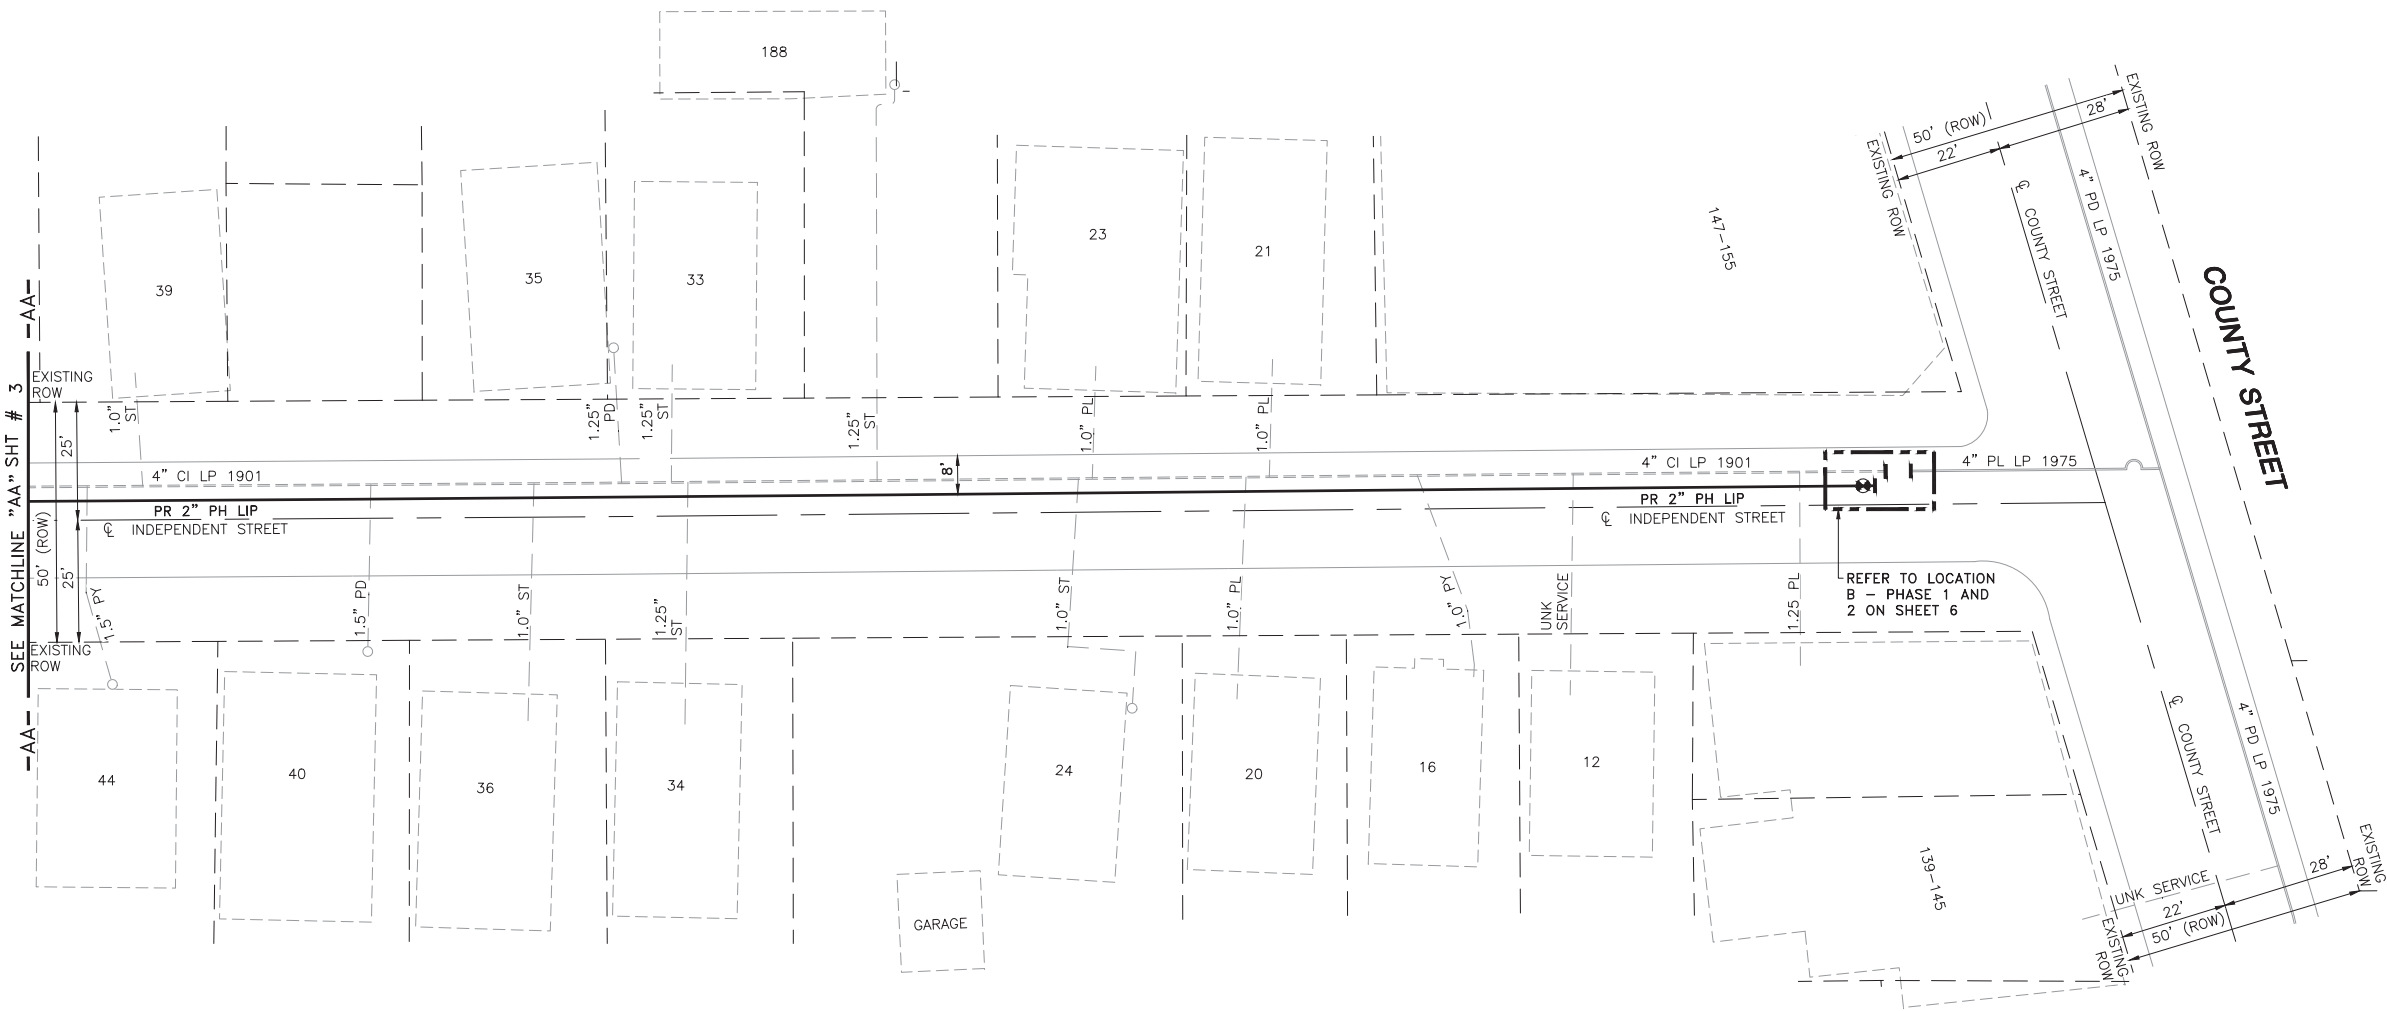

DRAWING LEGEND

	UTILITY POLE		EXISTING GAS MAIN
	LIGHT POLE		RETIRED GAS MAIN
	CATCH BASIN		PROPOSED GAS MAIN
	FIRE HYDRANT		EXISTING SERVICE
	UTILITY MANHOLE		RIGHT OF WAY
	ELECTRIC MANHOLE		ELECTRIC
	TELEPHONE MANHOLE		TELEPHONE
	WATER MANHOLE		WATER
	SANITARY MANHOLE		SANITARY SEWER
	STORM MANHOLE		STORM SEWER
	EXISTING REDUCER		PROPOSED REDUCER
	EXISTING CAP		PROPOSED CAP
	EXISTING VALVE		PROPOSED VALVE
	EXISTING COUPLING		PROPOSED ANODE

- NOTES:
- CONTRACTOR TO POTHOLE EXISTING UTILITIES AT CROSSING LOCATIONS PRIOR TO CONSTRUCTION.
 - REFER TO GENERAL NOTES AND SCHEDULE OF MATERIALS ON SHEET #2.

LENGTH	SIZE	MATERIAL	DESCRIPTION
385'	2"	PH	INSTALL
385'	4"	CI	RETIRE

ISSUED FOR
CONSTRUCTION
01/11/2021

SEALED BY:



SIGNATURE

SEALED ON:

01/11/2021

LICENSE EXPIRATION:

06/30/2022

DESIGNED IN ACCORDANCE WITH TITLE 49, PART 192 OF MINIMUM FEDERAL SAFETY STANDARDS AND GPTC GUIDE FOR GAS TRANSMISSION AND DISTRIBUTION PIPING SYSTEMS, LATEST EDITION.

ENEngineering

29 BARTLETT STREET
MARLBOROUGH, MA 01752
TEL (630) 353-4000
FAX (630) 335-7777
WWW.ENENGINEERING.COM

FIELD VERIFY DIMENSIONS
PRIOR TO PIPE FABRICATION

0	ISSUED FOR CONSTRUCTION	01/11/2021	RT/AB/EK
NO.	DESCRIPTION	DATE	DW/CK/AP

REVISION STATUS

EVERSOURCE
ENERGY

INDEPENDENT STREET MAIN RELAY
NEW BEDFORD, MASSACHUSETTS

INSTALLATION PLAN

SCALE: 1"=20' (DO NOT SCALE FROM DRAWINGS) SHEET 4 OF 7

DRAWN BY / DATE KT 10/19/2020	CHECKED BY / DATE AB 01/11/2021	SHEET NUMBER MA-NEB-21-PIP-010-04	REV. NO. 0
APPROVED BY / DATE EK 01/11/2021	MANEB21PIP010R0		