

APPLICATION/AGREEMENT
For Trench/Disturbance Permit within the City of New Bedford

Permit # 385-2021
Dig Safe# _____
Date: 09/13/21

TO THE MAYOR AND CITY COUNCIL: DISTURBANCE PERMIT/TRENCH SAFETY PERMIT

Permission is hereby requested to excavate the surface of: X City Property and/or X Private Property
Provide Sketch

Location of Work: Bedford St.

From intersection of Bedford & West St., continuing west to intersection of Bedford & Brigham St. 40 ft in all directions

At all intersections.

Relay Gas Main & Services

Work will begin (weather permitting) on: September 20, 2021

Applicant Name: Thomas Costa (lml) Excavator(s) Name: _____

Company Name: Eversource Hoisting Equipment License Number: _____
Grade: _____ Expiration Date: _____

Contact Number: 508-441-5817 Name & Contact Number of Insurer: _____

Competent Person on Work Site: ON FILE

APPROVED BY: Stephen Caplan DATE: 9-20-2021
TITLE: Asst. City Engineer

This permit shall be posted at the work site, and shall remain until the work is completed. It is subject to inspection at all times.


PATCH REPAIR: Curb line to center of road

Adjust structures as needed. All existing
wheelchair ramps abutting final paving must be
ADA compliant and built in accordance with City
of New Bedford's Construction Standards. WCRs
must be installed prior to final paving.




EVERSOURCE ENERGY

TABER STREET, ELIZABETH STREET AND BEDFORD STREET MAIN RELAYS
INSTALLATION OF 1115' OF 2" PH LIP GAS MAIN
TABER STREET, ELIZABETH STREET AND BEDFORD STREET
NEW BEDFORD, MASSACHUSETTS
ENE PROJECT #: 2005881.37
EVERSOURCE PROJECT #: 1667002

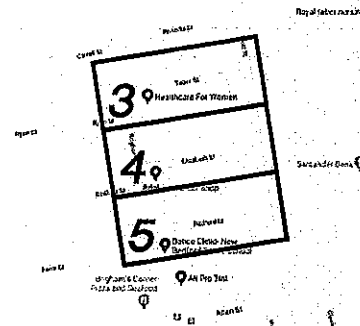

LOCUS PLAN
NOT TO SCALE

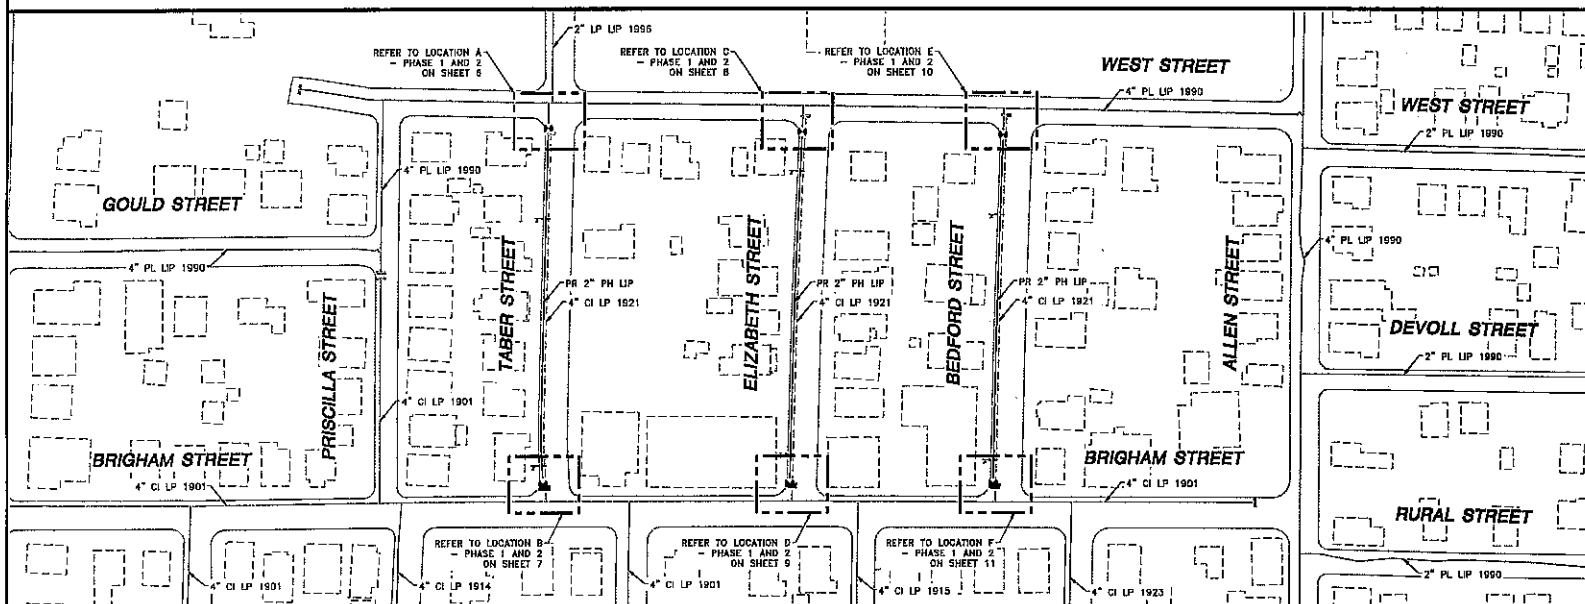

NOTE:
EXISTING CONDITIONS SHOWN ARE BASED ON GIS, AERIAL AND AVAILABLE RECORD DATA.
NO FIELD SURVEY WAS PERFORMED. CONTRACTOR TO VERIFY EXISTING CONDITIONS AS
NEEDED IN THE FIELD. PROPOSED MAIN ALIGNMENT AND OFFSETS ARE APPROXIMATE.

SITE PLAN

NEW BEDFORD, MASSACHUSETTS
(SCALE: 1"=50')
(DO NOT SCALE FROM DRAWINGS)

SHEET NUMBER	DESCRIPTION	DATE	BY
1	IFC - NO CHANGES THIS SHEET	08/08/2021	LR
0	ISSUED FOR CONSTRUCTION	08/28/2021	ZS
NO.	DESCRIPTION	DATE	DW

REVISION STATUS
EVERSOURCE
ENERGY

TABER STREET, ELIZABETH STREET AND BEDFORD STREET MAIN F
NEW BEDFORD, MASSACHUSETTS
SITE PLAN, LOCUS PLAN AND SHEET INDEX

SCALE: AS NOTED	SHEET NUMBER
SCALE: AS NOTED	SHEET 1
DESIGNED BY DATE AS 08/08/2021	CHECKED BY DATE MANEB21P-077R1
APPROVED BY DATE 08/08/2021	SHEET NUMBER MA-NEB-21-P-077-01

 


ISSUED FOR
CONSTRUCTION
08/06/2021



DESIGNED BY
08/11/2021
SIGNATURE
08/20/2022

DESIGNED BY ACCORDANCE WITH TITLE
45B, CHAPTER 18B, REGULATION 18B.00(1)
"REGISTERED PROFESSIONAL ENGINEER"
SYSTEMS LATEST EDITION
ENE Engineering
21 BEDFORD STREET
MASSACHUSETTS 01902
TEL: 508-528-7777
WWW.ENENGINEERING.COM

FIELD VERIFY DIMENSIONS
PRIOR TO PIPE FABRICATION

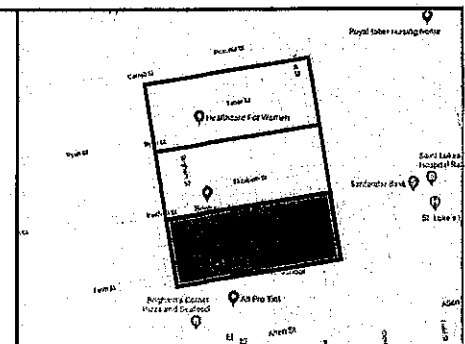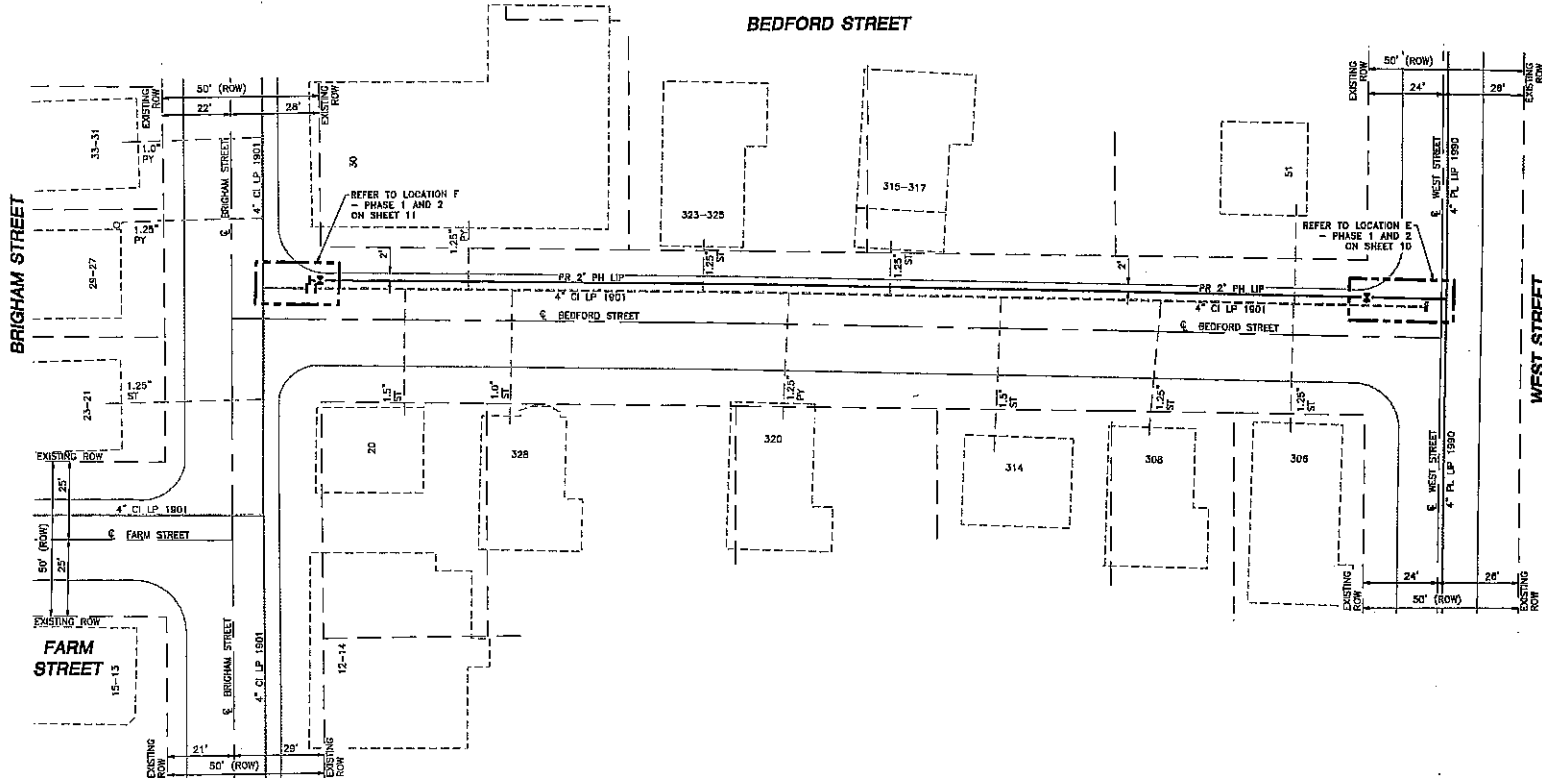

DRAWING LEGEND		
	UTILITY POLE	EXISTING GAS MAIN
	LIGHT POLE	RETIRED GAS MAIN
	CATCH BASIN	PROPOSED GAS MAIN
	FIRE HYDRANT	EXISTING SERVICE
	UTILITY MANHOLE	RIGHT OF WAY
	ELECTRIC MANHOLE	ELECTRIC
	TELEPHONE MANHOLE	TELEPHONE
	WATER MANHOLE	WATER
	SANITARY MANHOLE	SANITARY SEWER
	STORM MANHOLE	STORM SEWER
	EXISTING REDUCER	PROPOSED REDUCER
	EXISTING CAP	PROPOSED CAP
	EXISTING VALVE	PROPOSED VALVE
	EXISTING COUPLING	PROPOSED ANODE

- NOTES:
1. REFER TO GENERAL NOTES ON SHEET #2.
 2. CONTRACTOR TO PATCH EXISTING UTILITIES AT CROSSING LOCATIONS PRIOR TO CONSTRUCTION.
 3. HOPE, 4710, SDR 11 ELBOWS TO BE INSTALLED AS REQUIRED TO FACILITATE OFFSETS BASED ON FIELD CONDITIONS.

ISSUED FOR CONSTRUCTION 08/06/2021	SEALED BY: 	SEALED ON: 08/11/2021	DESIGNED IN ACCORDANCE WITH THE 4000 PSI OF TENSILE STRENGTH STANDARD AND SPECIFICATIONS TRANS. INTERNATIONAL EDITION	FIELD VERIFY DIMENSIONS PRIOR TO PIPE FABRICATION							
LENGTH SIZE MATERIAL DESCRIPTION <table><tr><td>370'</td><td>2"</td><td>PH</td><td>INSTALL</td></tr><tr><td>360'</td><td>4"</td><td>CI</td><td>RETIRE</td></tr></table>	370'	2"	PH	INSTALL	360'	4"	CI	RETIRE	LOGS EXPIRATION: 06/30/2022	ENGINEERING 20 BARTLETT STREET MAINE SPRINGFIELD, MA 01104 PHONE: 603.882.7777 WWW.EVERSOURCE.COM	REVISION STATUS EVERSOURCE ENERGY TABER STREET, ELIZABETH STREET AND BEDFORD STREET MAIN RELAYS NEW BEDFORD, MASSACHUSETTS INSTALLATION PLAN SCALE: 1"=20' (DO NOT SCALE FROM DRAWINGS) SHEET 3 OF 12 DRAWN BY / DATE: JSM / 08/06/2021 CHECKED BY / DATE: JSM / 08/06/2021 APPROVED BY / DATE: JSM / 08/06/2021 MANES21PIP07TR1 SHEET NUMBER: MA-NEB-21-PIP-07-03 REV. NO: 1
370'	2"	PH	INSTALL								
360'	4"	CI	RETIRE								