

APPLICATION/AGREEMENT
For Trench/Disturbance Permit within the City of New Bedford

Permit # 386-2021
Dig Safe# _____
Date: 09/13/21

TO THE MAYOR AND CITY COUNCIL: DISTURBANCE PERMIT/TRENCH SAFETY PERMIT

Permission is hereby requested to excavate the surface of: X City Property and/or X Private Property
Provide Sketch

Location of Work: Elizabeth St.

From intersection of Elizabeth & West St., continuing west to intersection of Elizabeth & Brigham St. 40 ft in all directions

At all intersections.

Relay Gas Main & Services

Work will begin (weather permitting) on: September 20, 2021

Applicant Name: Thomas Costa (lml) Excavator(s) Name: _____

Company Name: Eversource Hoisting Equipment License Number: _____
Grade: _____ Expiration Date: _____

Contact Number: 508-441-5817 Name & Contact Number of Insurer: _____

Competent Person on Work Site: ON FILE

APPROVED BY: Stephen Cyprian DATE: 9-20-2021

TITLE: Asst. City Engineer


This permit shall be posted at the work site, and shall remain until the work is completed. It is subject to inspection at all times.

PATCH REPAIR: Curb line to center of road

Adjust structures as needed. All existing wheelchair ramps abutting final paving must be ADA compliant and built in accordance with City of New Bedford's Construction Standards. WCRs must be installed prior to final paving.


EVERSOURCE ENERGY

TABER STREET, ELIZABETH STREET AND BEDFORD STREET MAIN RELAYS
INSTALLATION OF 1115' OF 2" PH LIP GAS MAIN
TABER STREET, ELIZABETH STREET AND BEDFORD STREET
NEW BEDFORD, MASSACHUSETTS
ENE PROJECT #: 2005881.37
EVERSOURCE PROJECT #: 1667002

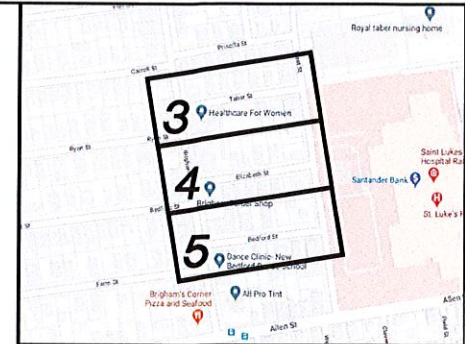

LOCUS PLAN
NOT TO SCALE

SHEET INDEX	
SHEET NUMBER	DESCRIPTION
1	SITE PLAN, LOCUS PLAN AND SHEET INDEX
2	GENERAL NOTES
3	INSTALLATION PLAN
4	INSTALLATION PLAN
5	INSTALLATION PLAN
6	LOCATION A - PHASE 1, 2 AND SCHEDULE OF MATERIALS
7	LOCATION B - PHASE 1, 2 AND SCHEDULE OF MATERIALS
8	LOCATION C - PHASE 1, 2 AND SCHEDULE OF MATERIALS
9	LOCATION D - PHASE 1, 2 AND SCHEDULE OF MATERIALS
10	LOCATION E - PHASE 1, 2 AND SCHEDULE OF MATERIALS
11	LOCATION F - PHASE 1, 2 AND SCHEDULE OF MATERIALS
12	STANDARD CORROSION DETAILS

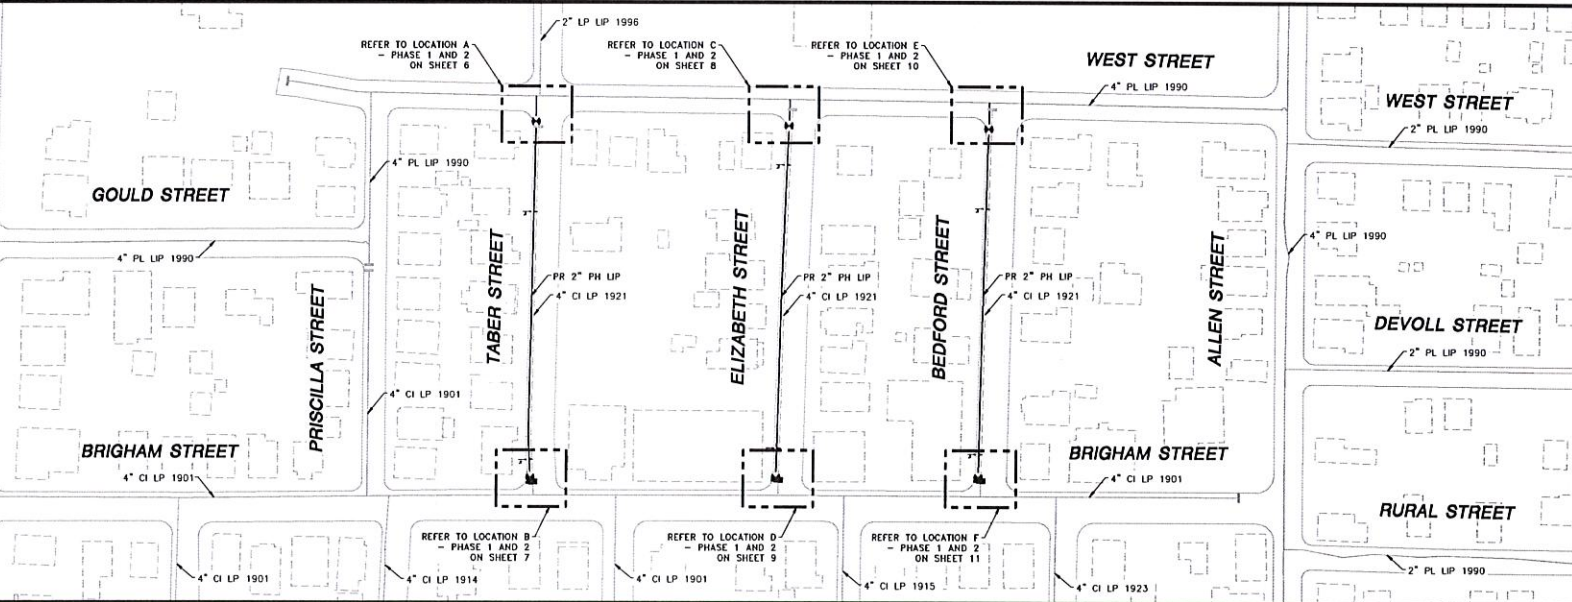

NOTE:
EXISTING CONDITIONS SHOWN ARE BASED ON GIS, AERIAL AND AVAILABLE RECORD DATA.
NO FIELD SURVEY WAS PERFORMED. CONTRACTOR TO VERIFY EXISTING CONDITIONS AS
NEEDED IN THE FIELD. PROPOSED MAIN ALIGNMENT AND OFFSETS ARE APPROXIMATE.

SITE PLAN
NEW BEDFORD, MASSACHUSETTS
(SCALE: 1"=60')
(DO NOT SCALE FROM DRAWINGS)

1	IFC - NO CHANGES THIS SHEET	08/06/2021	LR/AB/IEK
0	ISSUED FOR CONSTRUCTION	06/28/2021	ZS/AB/IEK
NO.	DESCRIPTION	DATE	DW/CK/AP

REVISION STATUS
EVERSOURCE
ENERGY

TABER STREET, ELIZABETH STREET AND BEDFORD STREET MAIN RELAYS
NEW BEDFORD, MASSACHUSETTS

SITE PLAN, LOCUS PLAN AND SHEET INDEX

SCALE: AS NOTED	SHEET 1 OF 12
DRAWN BY: DATE ZS 05/14/2021	CHECKED BY: DATE AB 08/06/2021
APPROVED BY: DATE EK 08/06/2021	MANEB21PIP077R1

ISSUED FOR
CONSTRUCTION
08/06/2021




SEALED BY
08/11/2021
LICENSE
EXPIRATION
06/30/2022

DESIGNED IN ACCORDANCE WITH TITLE
45, CHAPTER 26B OF AN ACT TO REGULATE
TRANSMISSION AND DISTRIBUTION OF GAS
SYSTEMS, LATEST EDITION.
ENEngineering
28 BARTLETT STREET
WALSHAM, MASSACHUSETTS 01974
TEL: 833-333-2777
WWW.ENENGINEERING.COM

FIELD VERIFY DIMENSIONS
PRIOR TO PIPE FABRICATION



ELIZABETH STREET

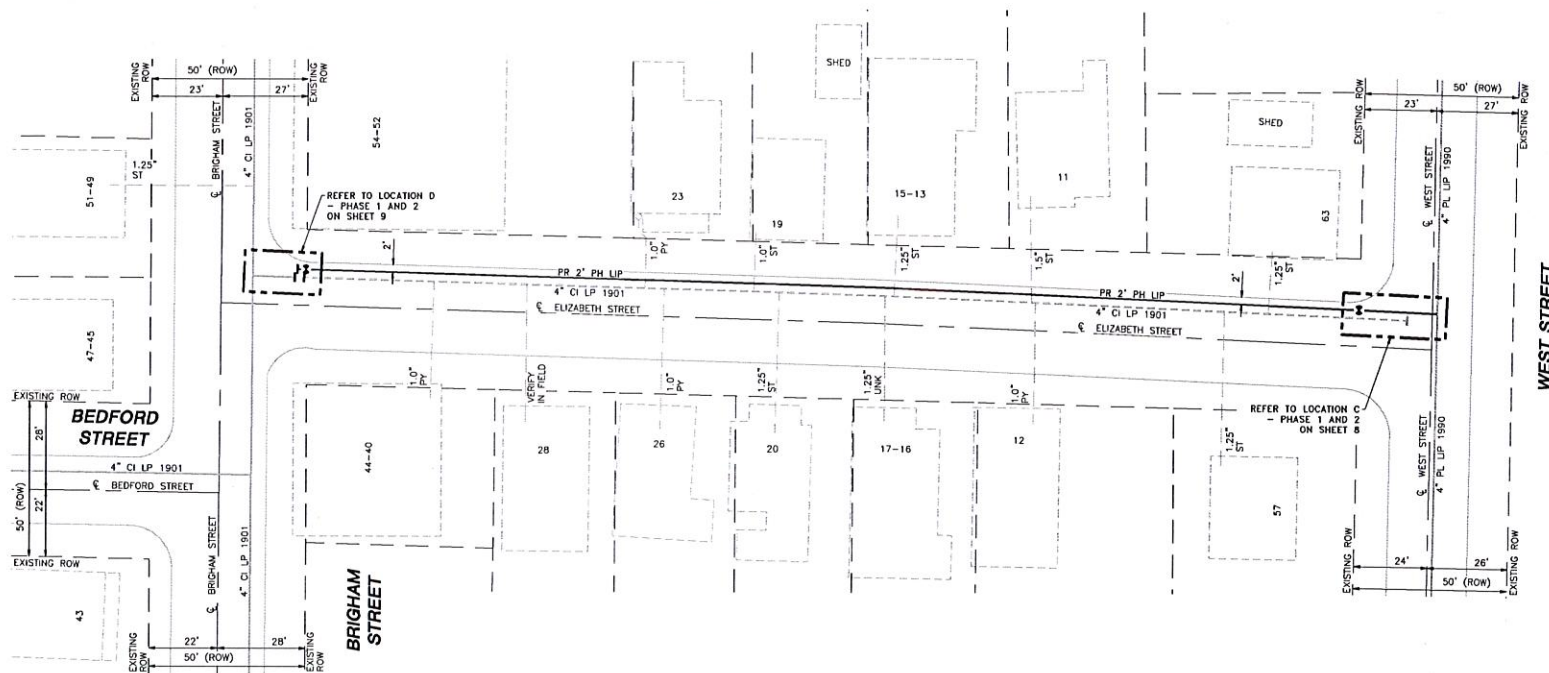

WEST STREET



LOCUS PLAN NOT TO SCALE


DRAWING LEGEND

UTILITY POLE	EXISTING GAS MAIN
LIGHT POLE	RETIRED GAS MAIN
CATCH BASIN	PROPOSED GAS MAIN
FIRE HYDRANT	EXISTING SERVICE
UTILITY MANHOLE	RIGHT OF WAY
ELECTRIC MANHOLE	ELECTRIC
TELEPHONE MANHOLE	TELEPHONE
WATER MANHOLE	WATER
SANITARY MANHOLE	SANITARY SEWER
STORM MANHOLE	STORM SEWER
EXISTING REDUCER	PROPOSED REDUCER
EXISTING CAP	PROPOSED CAP
EXISTING VALVE	PROPOSED VALVE
EXISTING COUPLING	PROPOSED ANODE

- NOTES
1. REFER TO GENERAL NOTES ON SHEET #2.
 2. CONTRACTOR TO POINTE OUT EXISTING UTILITIES AT CROSSING LOCATIONS PRIOR TO CONSTRUCTION.
 3. HDPE 4710 SDR 11 ELBOWS TO BE INSTALLED AS REQUIRED TO FACILITATE OFFSETS BASED ON FIELD CONDITIONS.

LENGTH	SIZE	MATERIAL	DESCRIPTION
370'	2"	PH	INSTALL
355'	4"	CI	RETIRE

ISSUED FOR
CONSTRUCTION
08/06/2021

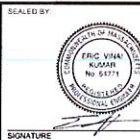

SEALED BY
08/11/2021
LICENSE EXPIRATION
05/30/2022

DESIGNED IN ACCORDANCE WITH TITLE 46A, CHAPTER 27B, SECTION 27B.01(1) STANDARD AND SPECIFICATIONS FOR ROAD SIGNS, LATEST EDITION.
ENEngineering
29 BARTLETT STREET
WALTHAM, MASSACHUSETTS 02451
(617) 320-9990
WWW.ENENGINEERING.COM

FIELD VERIFY DIMENSIONS
PRIOR TO PIPE FABRICATION

REVISION STATUS			
EVERSOURCE ENERGY			
TABER STREET, ELIZABETH STREET AND BEDFORD STREET MAIN RELAYS NEW BEDFORD, MASSACHUSETTS			
INSTALLATION PLAN			
SCALE: 1"=20' (DO NOT SCALE FROM DRAWINGS)			SHEET 3 OF 12
DRAWN BY / DATE ZS 05/14/2021	CHECKED BY / DATE AB 08/05/2021	SHEET NUMBER MA-NEB-21-PIP-077-03	
APPROVED BY / DATE EK 08/05/2021	REV. NO. 1		