



NOTES (MISSY PLAINVILLE ROAD)

- 1.) PROTECTIVE IMPERMEABLE LINING IS NOT NEEDED TO PREVENT LEAKAGE OF LAND IN NEW BEDFORD, MA, FOR LAKES AND RIVERS.
- 2.) DANBURY CHEMISTRY & ENGINEERING CO. DATED FEBRUARY 19, 1991
- 3.) FIELD DEPTH INFORMATION BASED ON AROUND THE GROUND AND TOP OF SURFACE BY THEBETTER ENGINEERING CORP. THEN ON NOVEMBER 22, 1991
- 4.) ELEVATIONS SHOWN ARE BASED ON MEAN SEA LEVEL TO WHICH SURVEYOR 226 TO CORRESPOND TO NEW BEDFORD CITY DATA.
- 5.) LOCATION OF STAIRS AND ELEVATIONS OF EMBANKMENTS WILL BE SHOWN AFTER CONSTRUCTION OF EMBANKMENTS AND FILL SHALL BE AS APPROXIMATELY SHOWN.
- 6.) THERE MAY BE OTHER ELEVATIONS OF EMBANKMENTS AND FILL MAJOR WHERE NOT FURTHERMORE, THIS INFORMATION IS NOT INTENDED TO BE CONSIDERED WORK IS IF VARIATIONS THAT WILL INFLUENCE TO DESIGN.
- 7.) FINISH FLOOR ELEVATIONS DETERMINED BY JAY FRENCH ASSOC. AND SERVICE TO BUILDING METER BY COMMONWEALTH GAS CO.



SITE CIVIL ENGINEER



PAVED WATERWAY
NOT TO SCALE

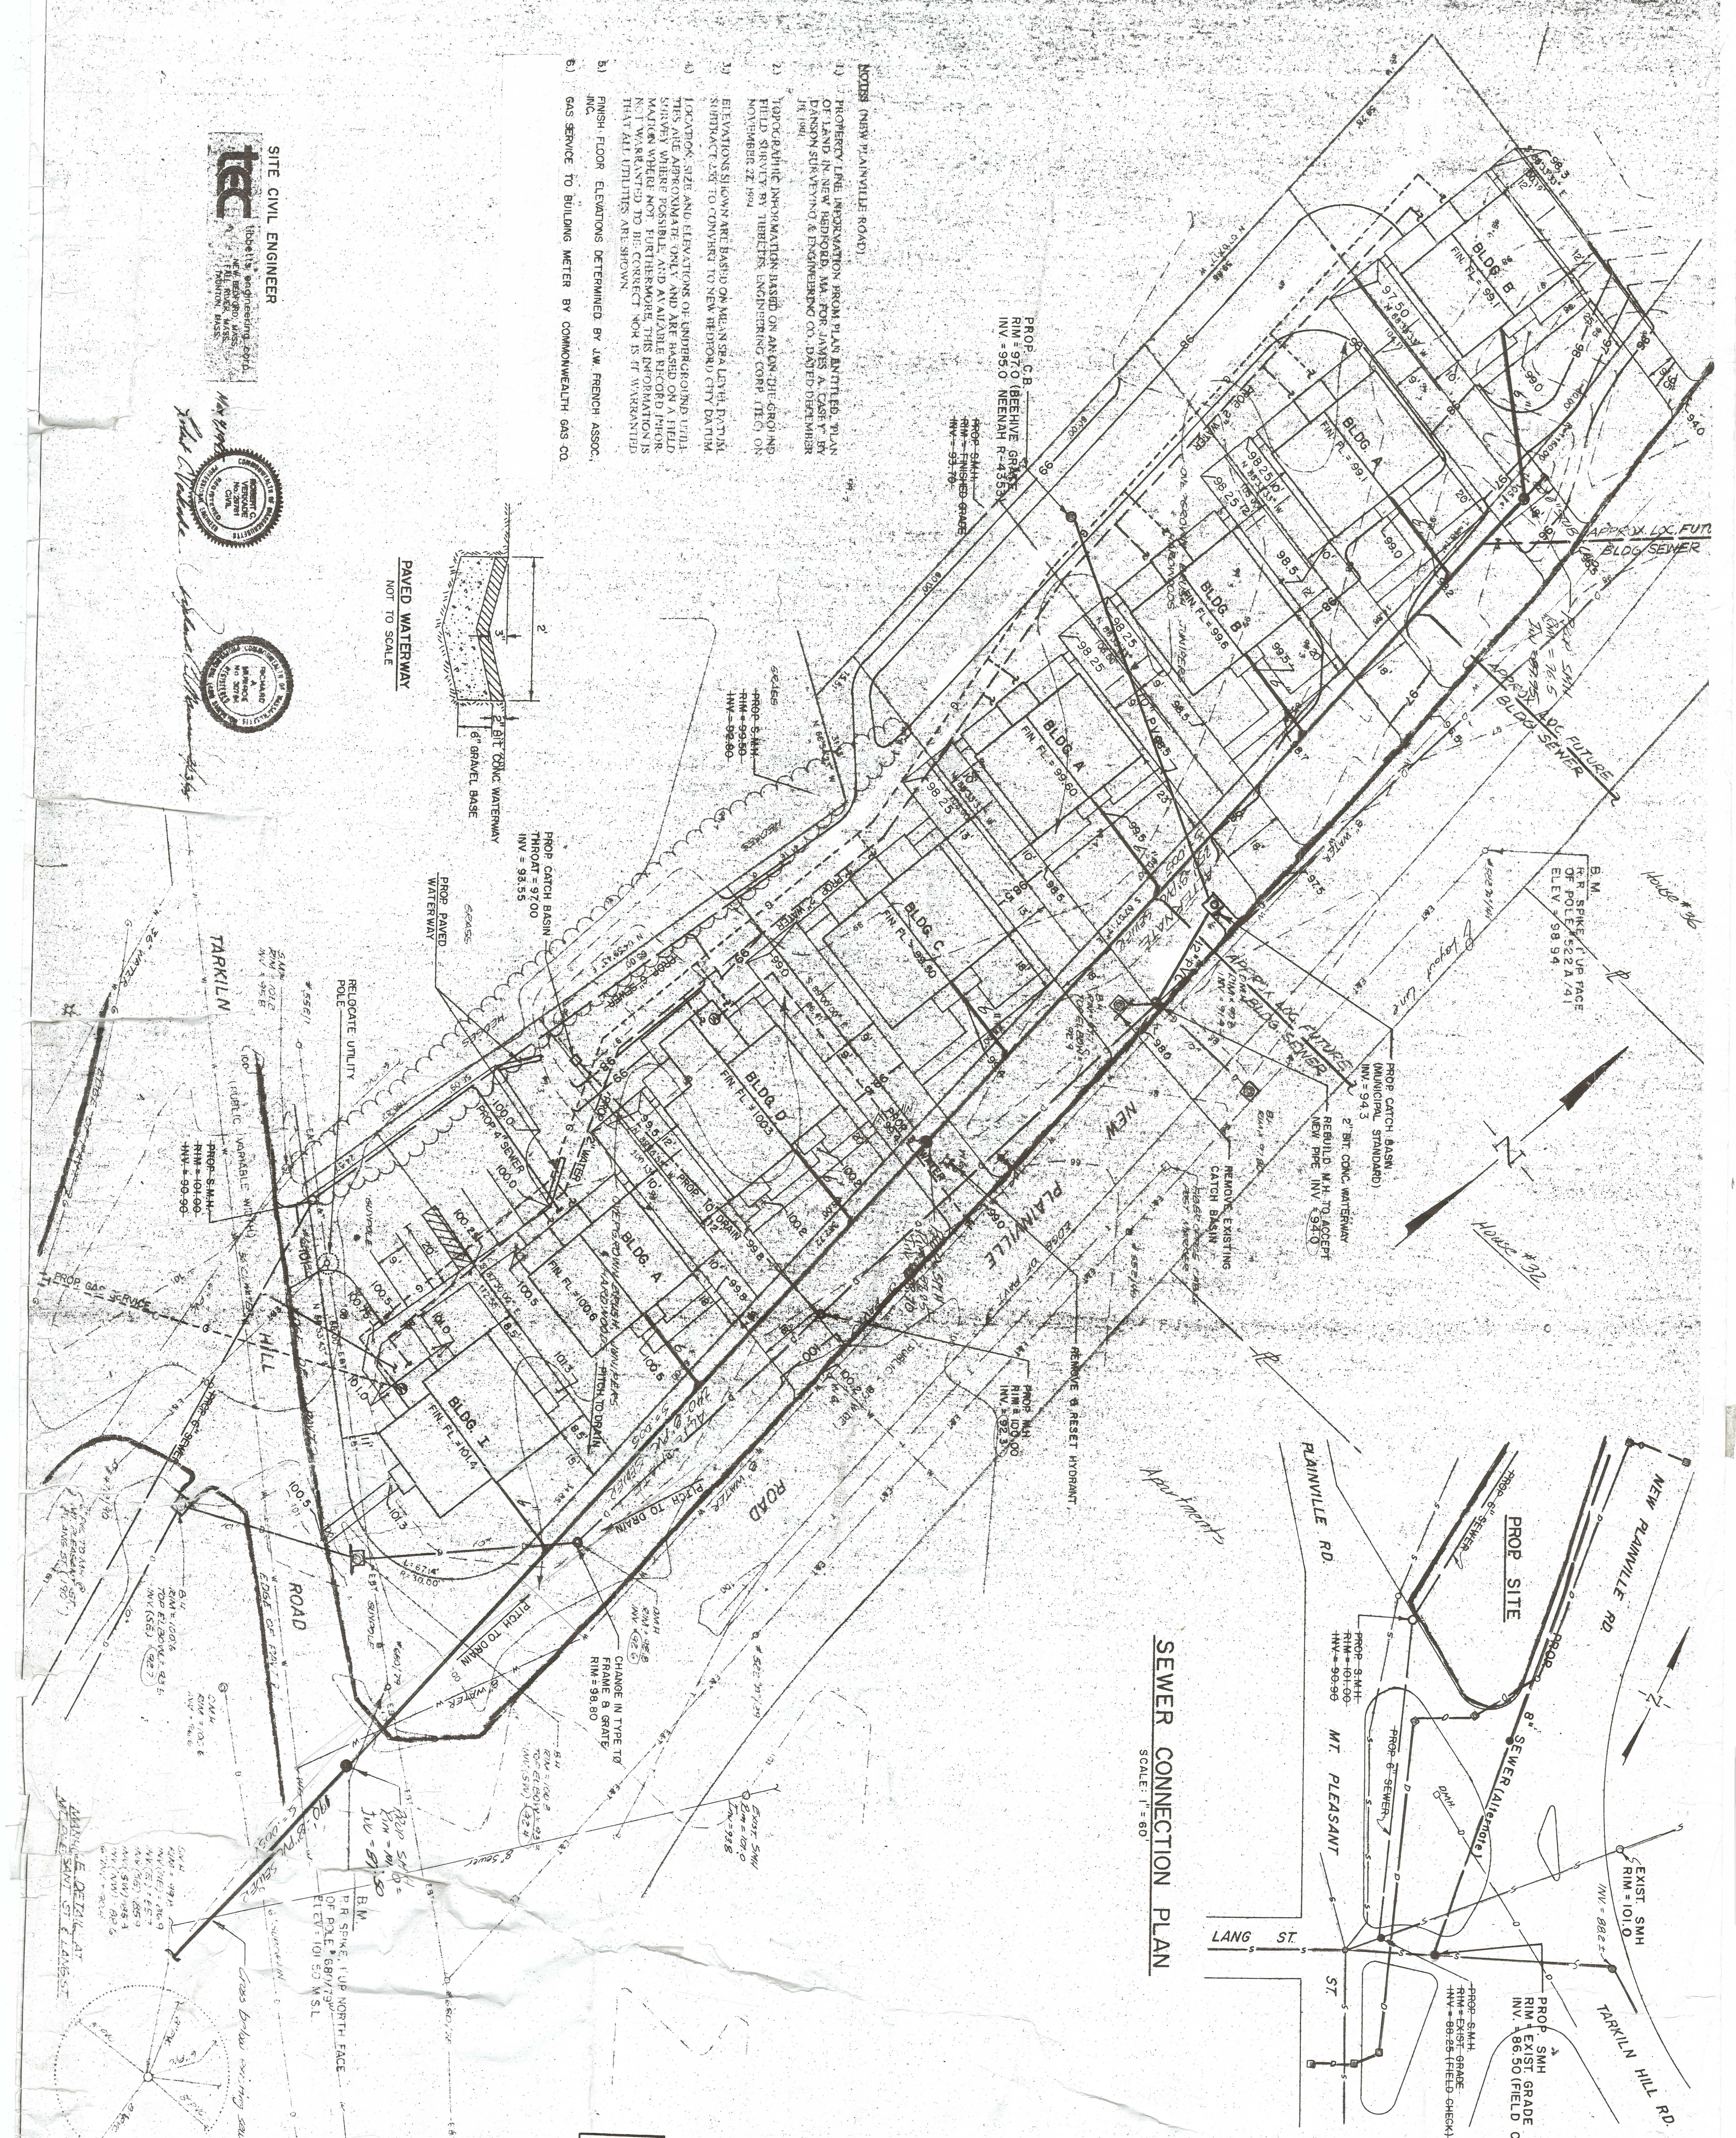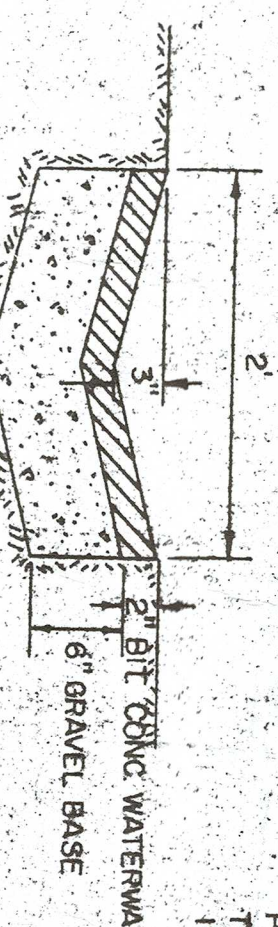

SEWER CONNECTION PLAN

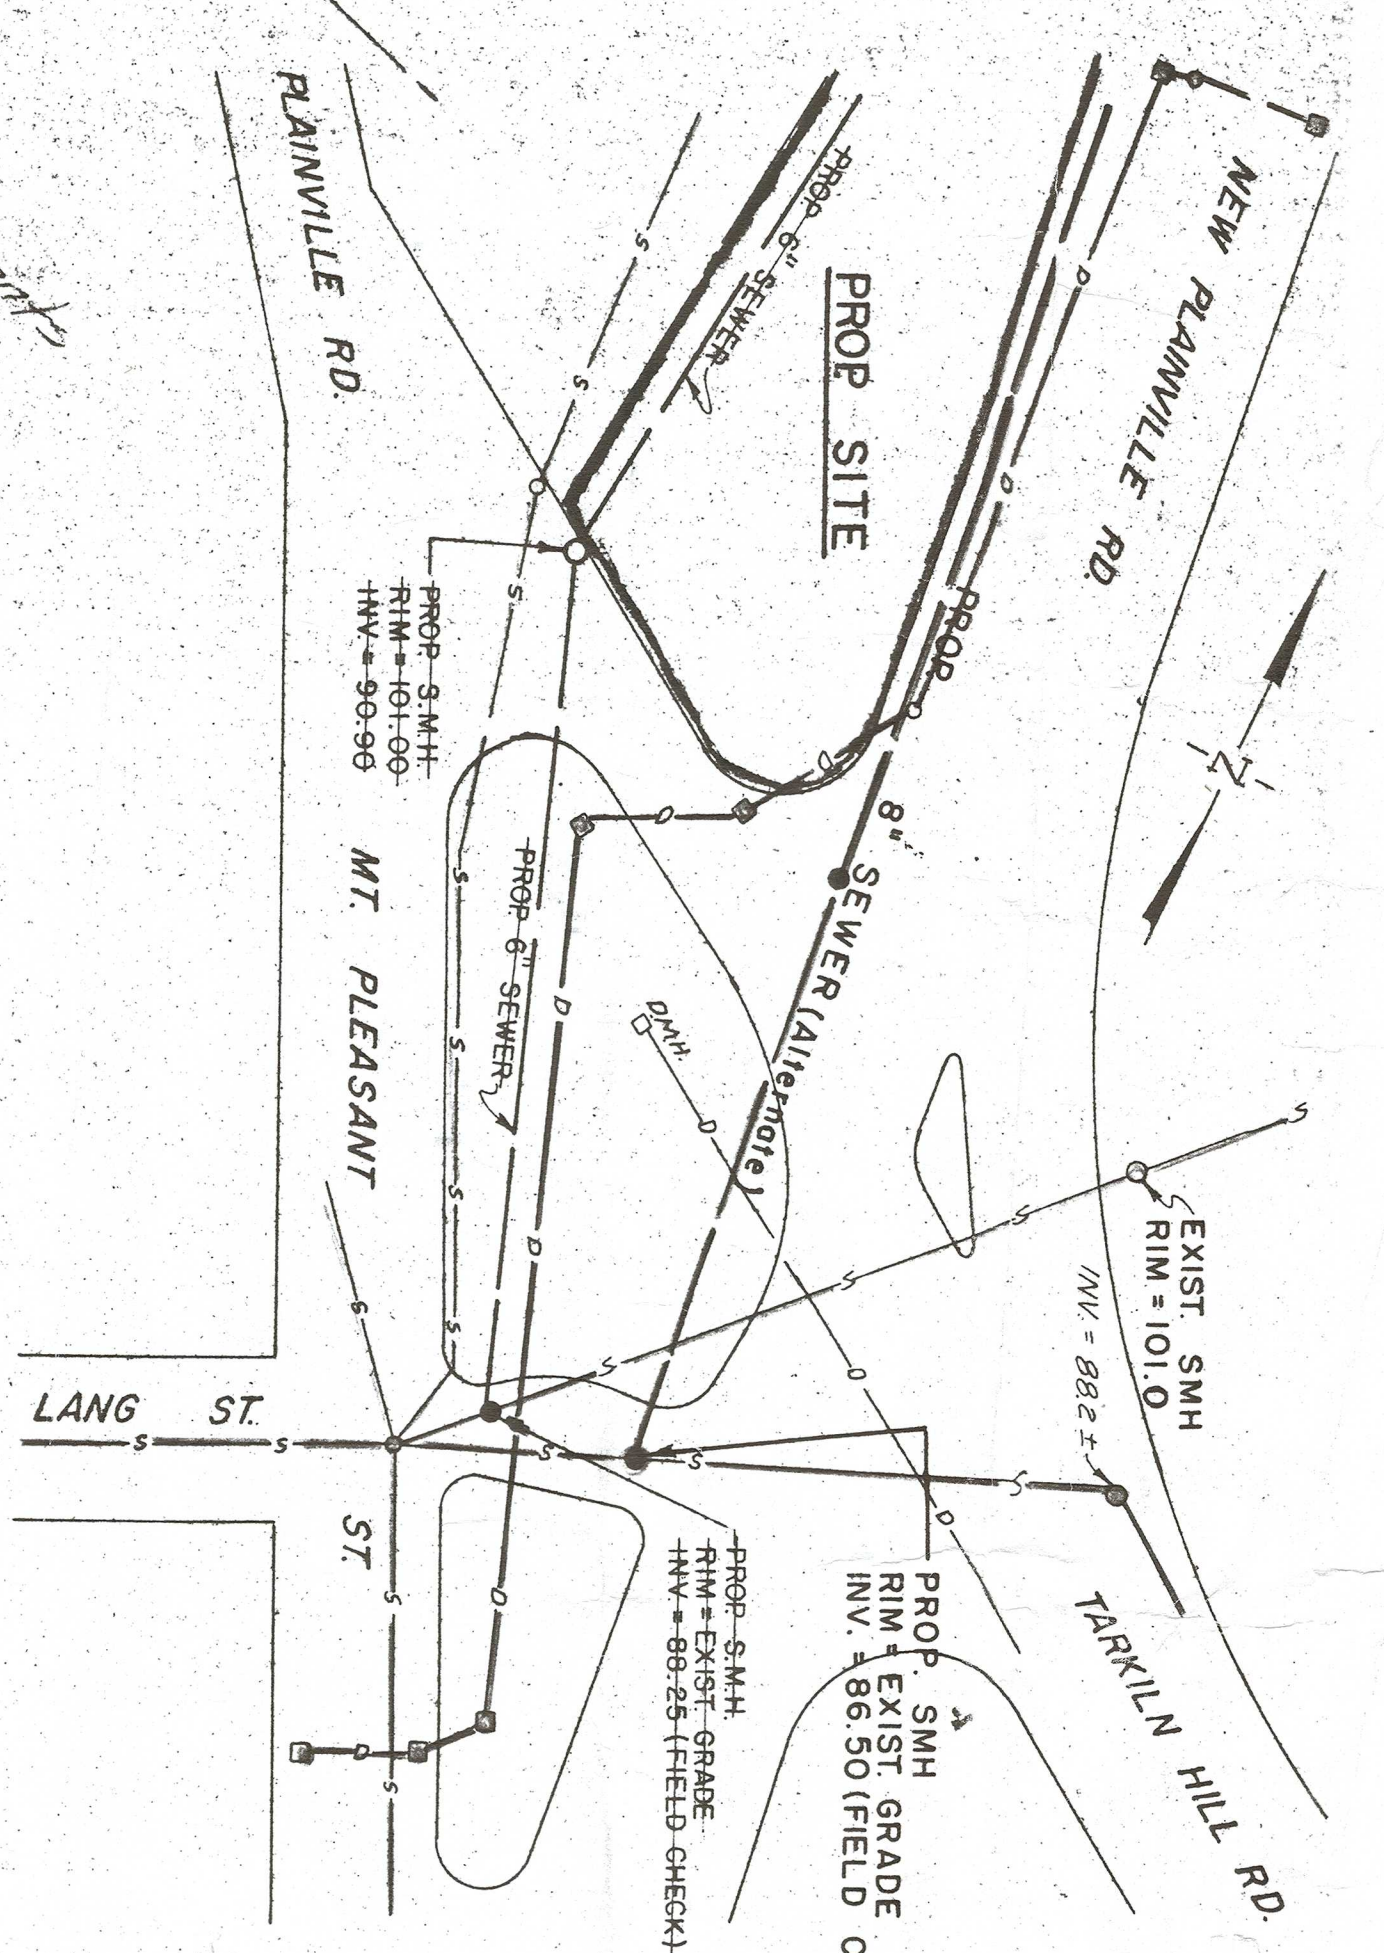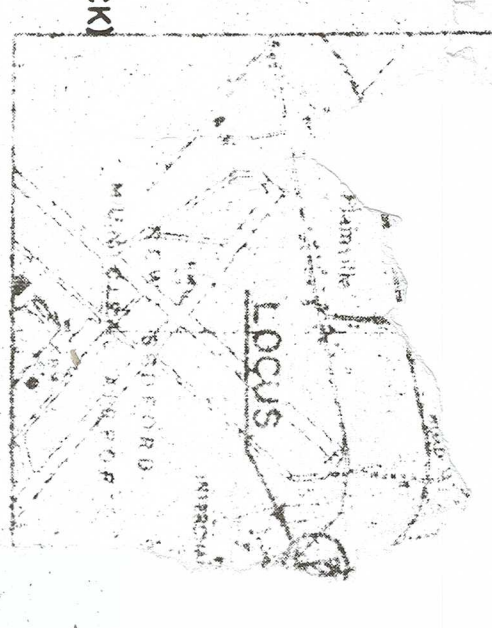LOCUS MAP

- | LEGEND: | |
|---------|-----------------------|
| 1 | SEWER LINE |
| 2 | WATER LINE |
| 3 | SEWER A STORM DRAIN |
| 4 | ELECTRIC TELEPHONE |
| 5 | CABLE TELEVISION |
| 6 | EXISTING CONDUIT |
| 7 | SEWER MANHOLE |
| 8 | CATCH BASIN |
| 9 | HYDRANT |
| 10 | WATER TREATMENT PLANT |
| 11 | RAS GATE |
| 12 | TELEPHONE |
| 13 | ELECTRIC |
| 14 | SEWER |
| 15 | STORM DRAIN |
| 16 | WATER |
| 17 | SEWER |
| 18 | STORM DRAIN |
| 19 | CITY |
| 20 | 8 |
| 21 | SEWER |
| 22 | STORM DRAIN |
| 23 | CATCH BASIN |
| 24 | HYDRANT |
| 25 | WATER TREATMENT PLANT |
| 26 | RAS GATE |
| 27 | TELEPHONE |
| 28 | ELECTRIC |
| 29 | SEWER |
| 30 | STORM DRAIN |
| 31 | WATER |
| 32 | SEWER |
| 33 | STORM DRAIN |
| 34 | CITY |
| 35 | 8 |
| 36 | SEWER |
| 37 | STORM DRAIN |
| 38 | CATCH BASIN |
| 39 | HYDRANT |
| 40 | WATER TREATMENT PLANT |
| 41 | RAS GATE |
| 42 | TELEPHONE |
| 43 | ELECTRIC |
| 44 | SEWER |
| 45 | STORM DRAIN |
| 46 | WATER |
| 47 | SEWER |
| 48 | STORM DRAIN |
| 49 | CITY |
| 50 | 8 |
| 51 | SEWER |
| 52 | STORM DRAIN |
| 53 | CATCH BASIN |
| 54 | HYDRANT |
| 55 | WATER TREATMENT PLANT |
| 56 | RAS GATE |
| 57 | TELEPHONE |
| 58 | ELECTRIC |
| 59 | SEWER |
| 60 | STORM DRAIN |
| 61 | WATER |
| 62 | SEWER |
| 63 | STORM DRAIN |
| 64 | CITY |
| 65 | 8 |
| 66 | SEWER |
| 67 | STORM DRAIN |
| 68 | CATCH BASIN |
| 69 | HYDRANT |
| 70 | WATER TREATMENT PLANT |
| 71 | RAS GATE |
| 72 | TELEPHONE |
| 73 | ELECTRIC |
| 74 | SEWER |
| 75 | STORM DRAIN |
| 76 | WATER |
| 77 | SEWER |
| 78 | STORM DRAIN |
| 79 | CITY |
| 80 | 8 |
| 81 | SEWER |
| 82 | STORM DRAIN |
| 83 | CATCH BASIN |
| 84 | HYDRANT |
| 85 | WATER TREATMENT PLANT |
| 86 | RAS GATE |
| 87 | TELEPHONE |
| 88 | ELECTRIC |
| 89 | SEWER |
| 90 | STORM DRAIN |
| 91 | WATER |
| 92 | SEWER |
| 93 | STORM DRAIN |
| 94 | CITY |
| 95 | 8 |
| 96 | SEWER |
| 97 | STORM DRAIN |
| 98 | CATCH BASIN |
| 99 | HYDRANT |
| 100 | WATER TREATMENT PLANT |

RECEIVED
NOV 3 0 1995
DEPT. OF PUBLIC WORKS
NEW BEDFORD, MASS

**EVERGREEN
PARK
REPLACEMENT
HOUSING**
NEW BEDFORD, MA
NEW BEDFORD HOUSING AUTHORITY
JOB NUMBER: MA 06-P007-02

J.W. FRENCH
ASSOCIATES, INC.
5 MONUMENT SQUARE
CHARLESTOWN, MA 021
617-242-7422

GRADING UTILITY
SITE PLAN
• NEW PLAINVILLE ROAD

REVIEWS 9/28/98 CITY	
REQUIREMENTS <u>W/IN 90-DAY STORM DRAIN</u>	
PROJECT NO. 9409	C-2
DRAWN BY: JLD	
DATE MAY 5, 1996	
SCALE: 1" = 20'	