




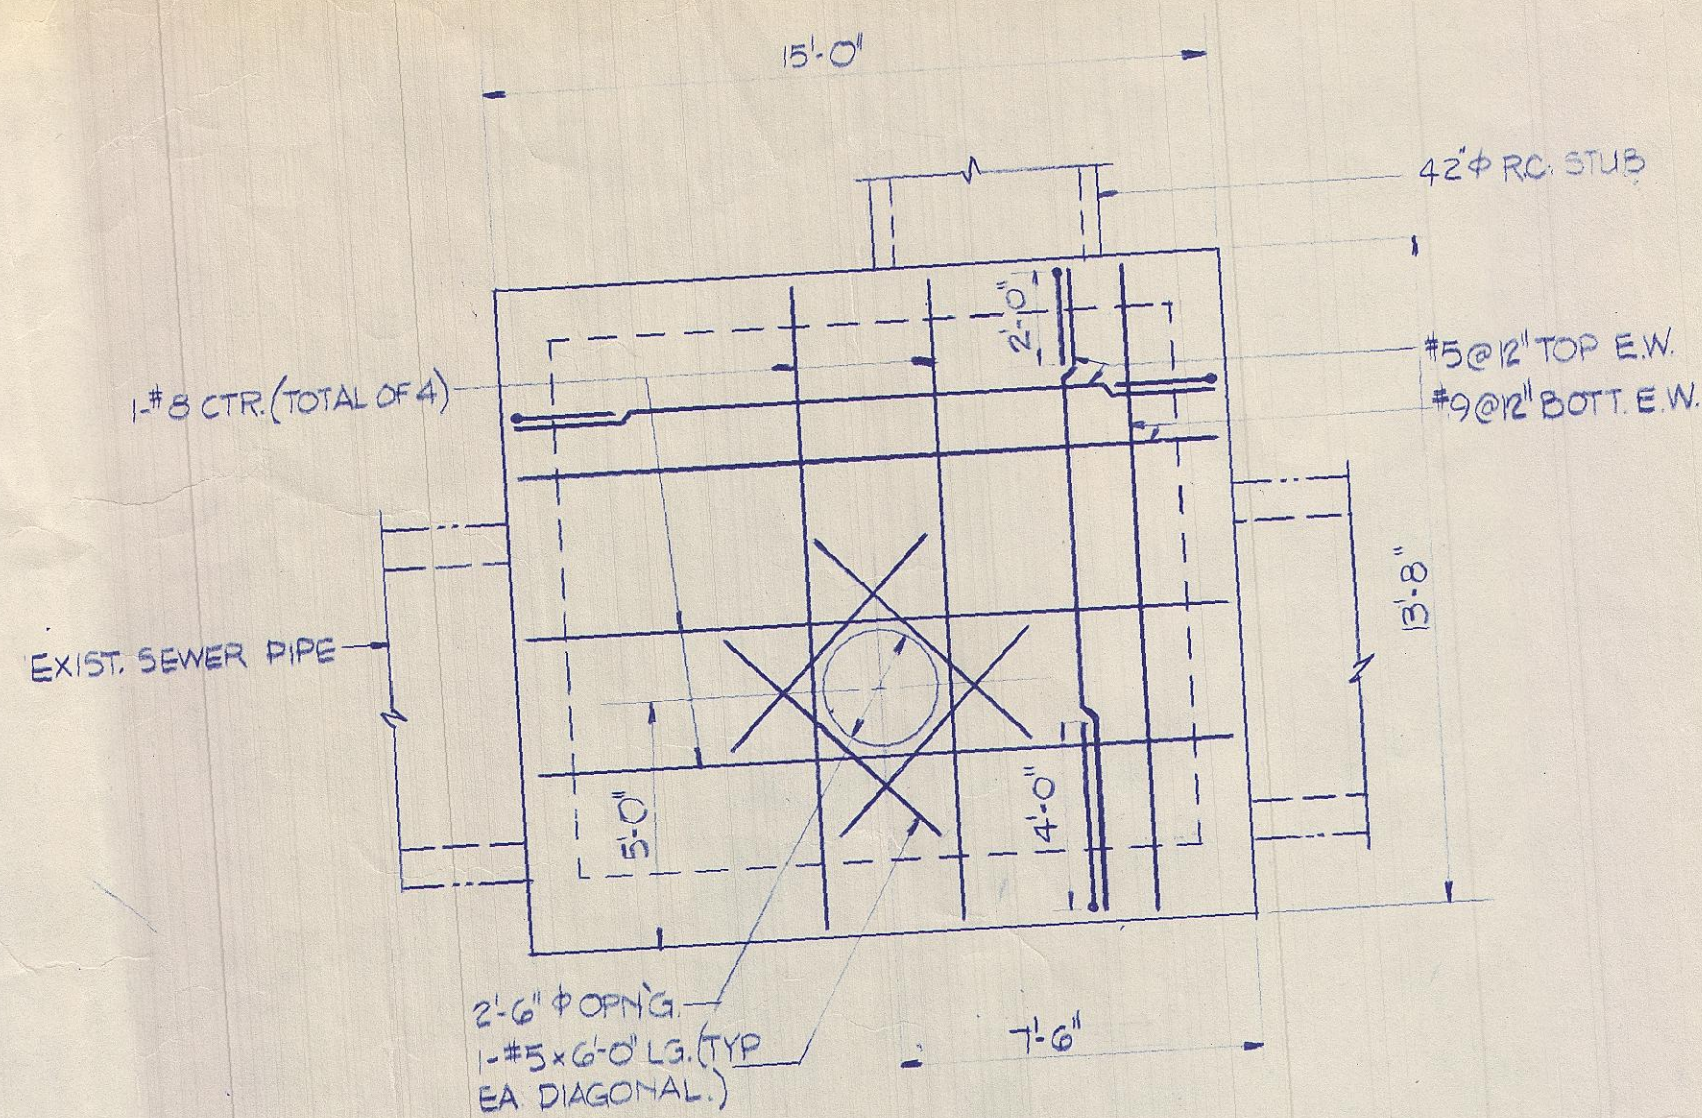

ROOF PLAN
NTS

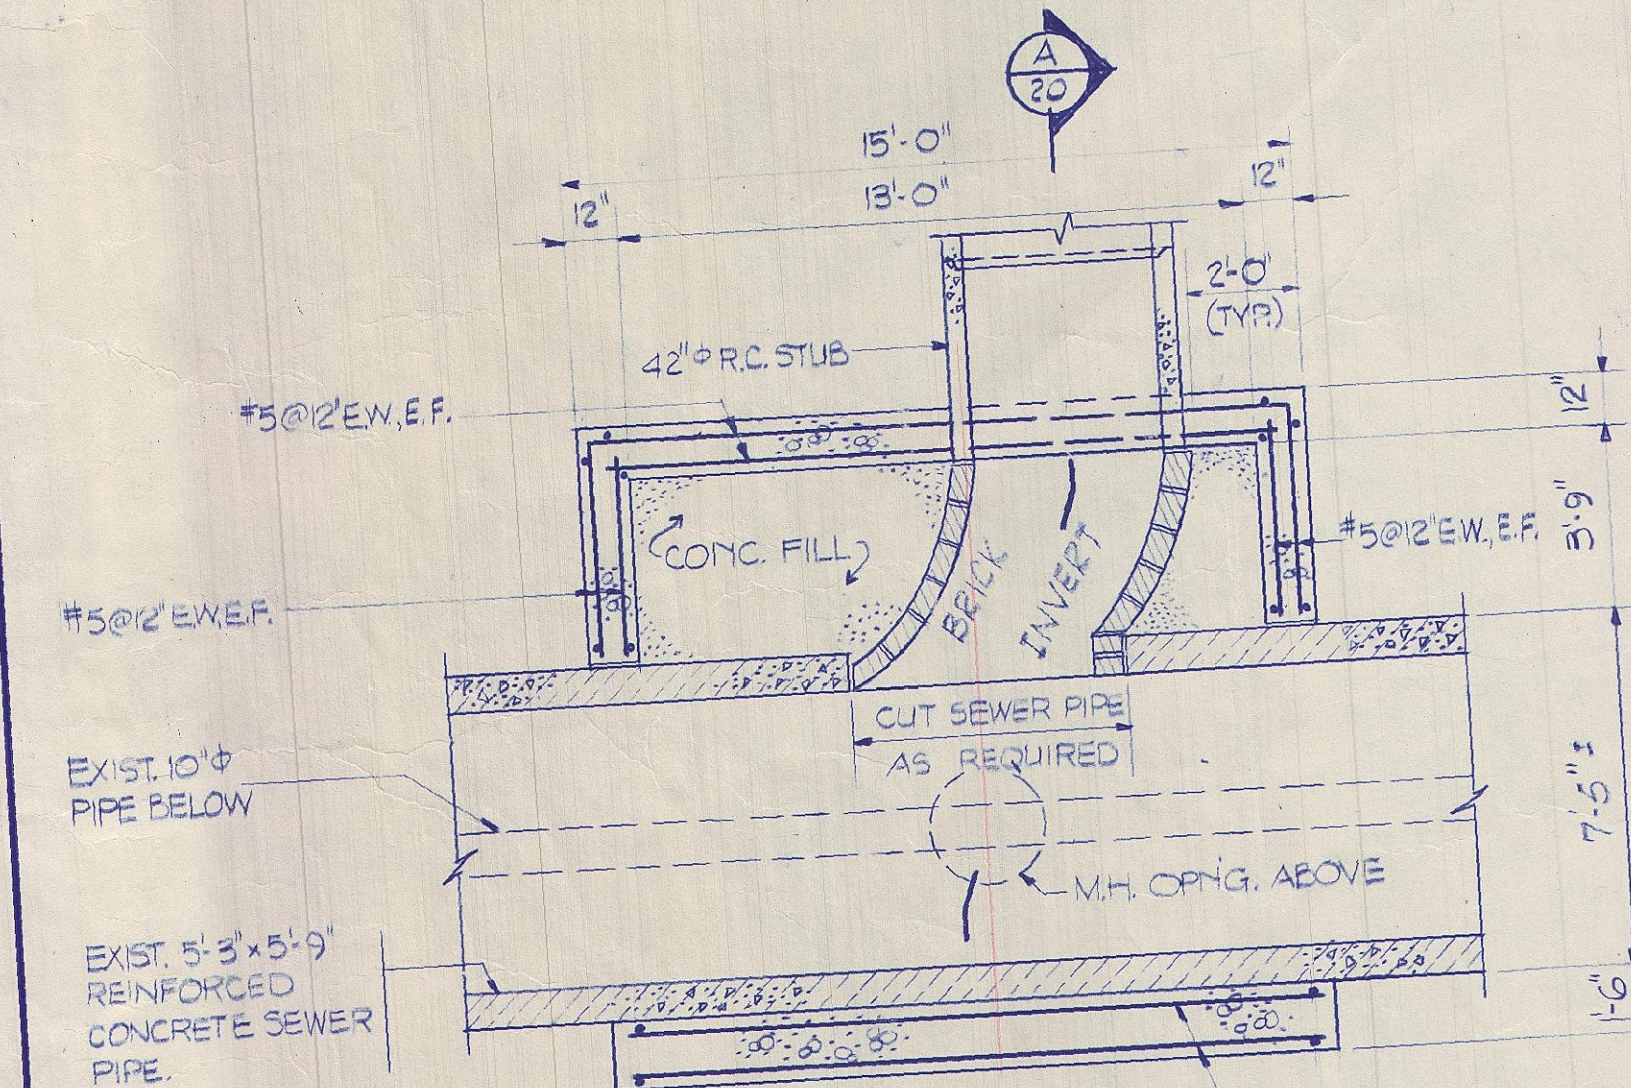


SECTIONAL PLAN
NTS

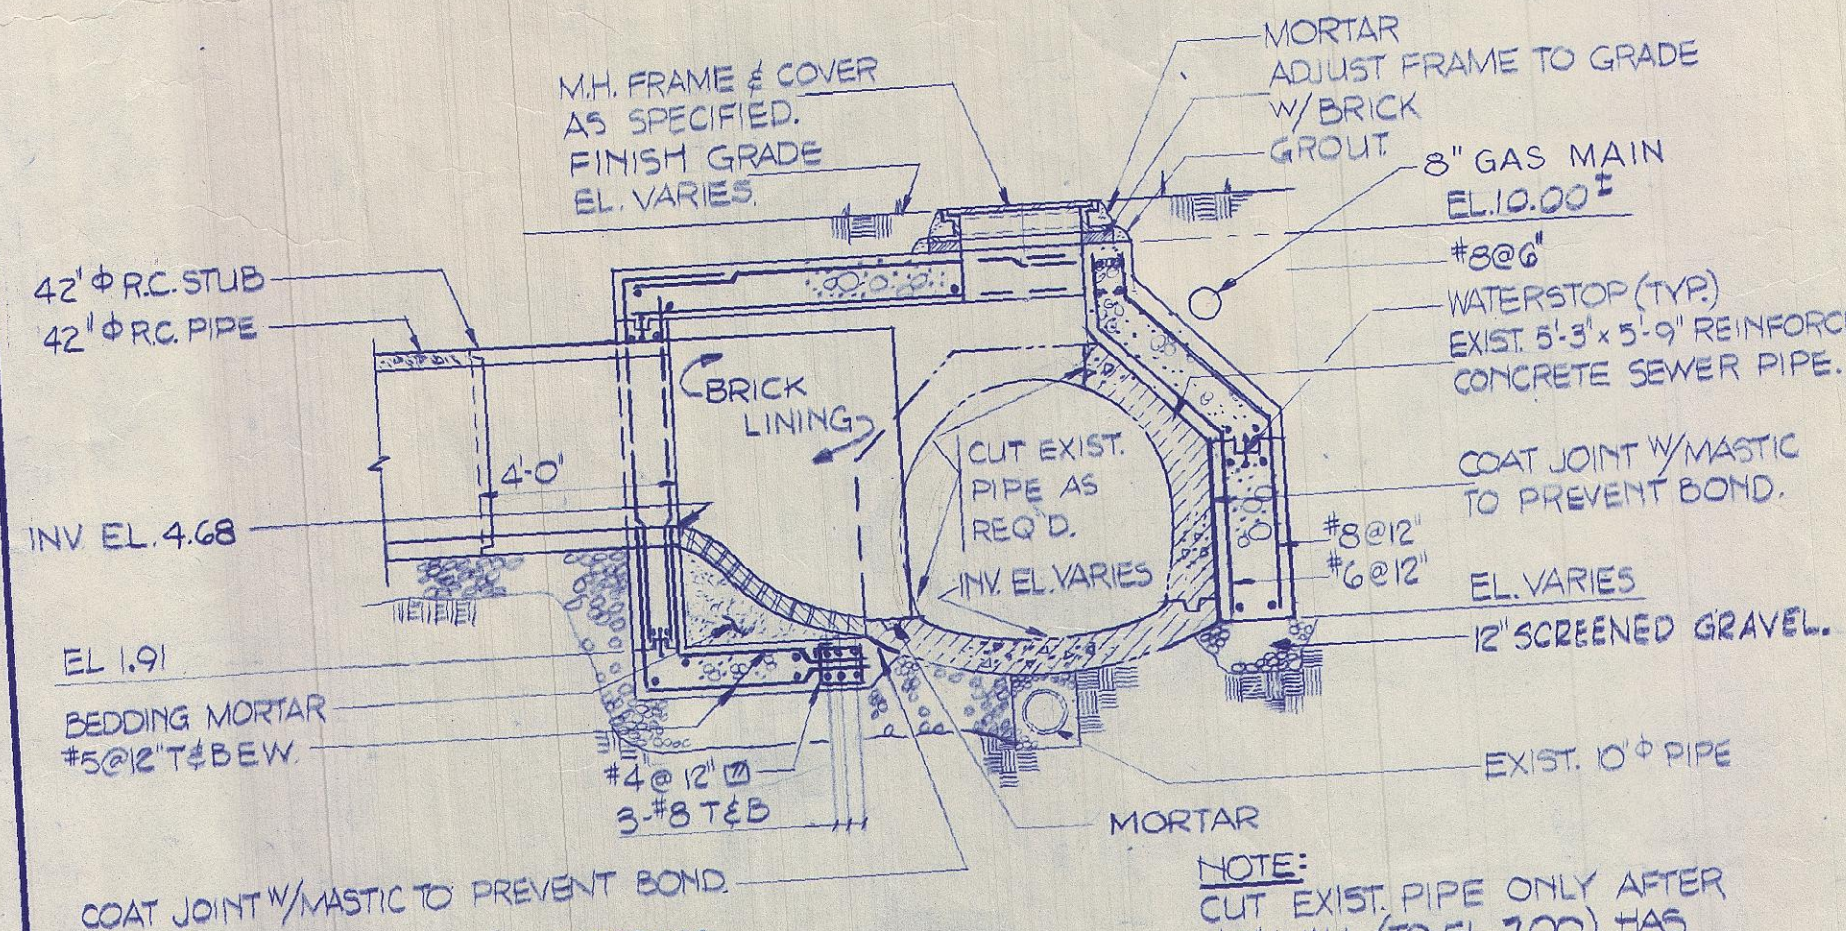


SECTION (A)
NTS


SPECIAL STRUCTURE STA. 0+00
(Item 2f.)

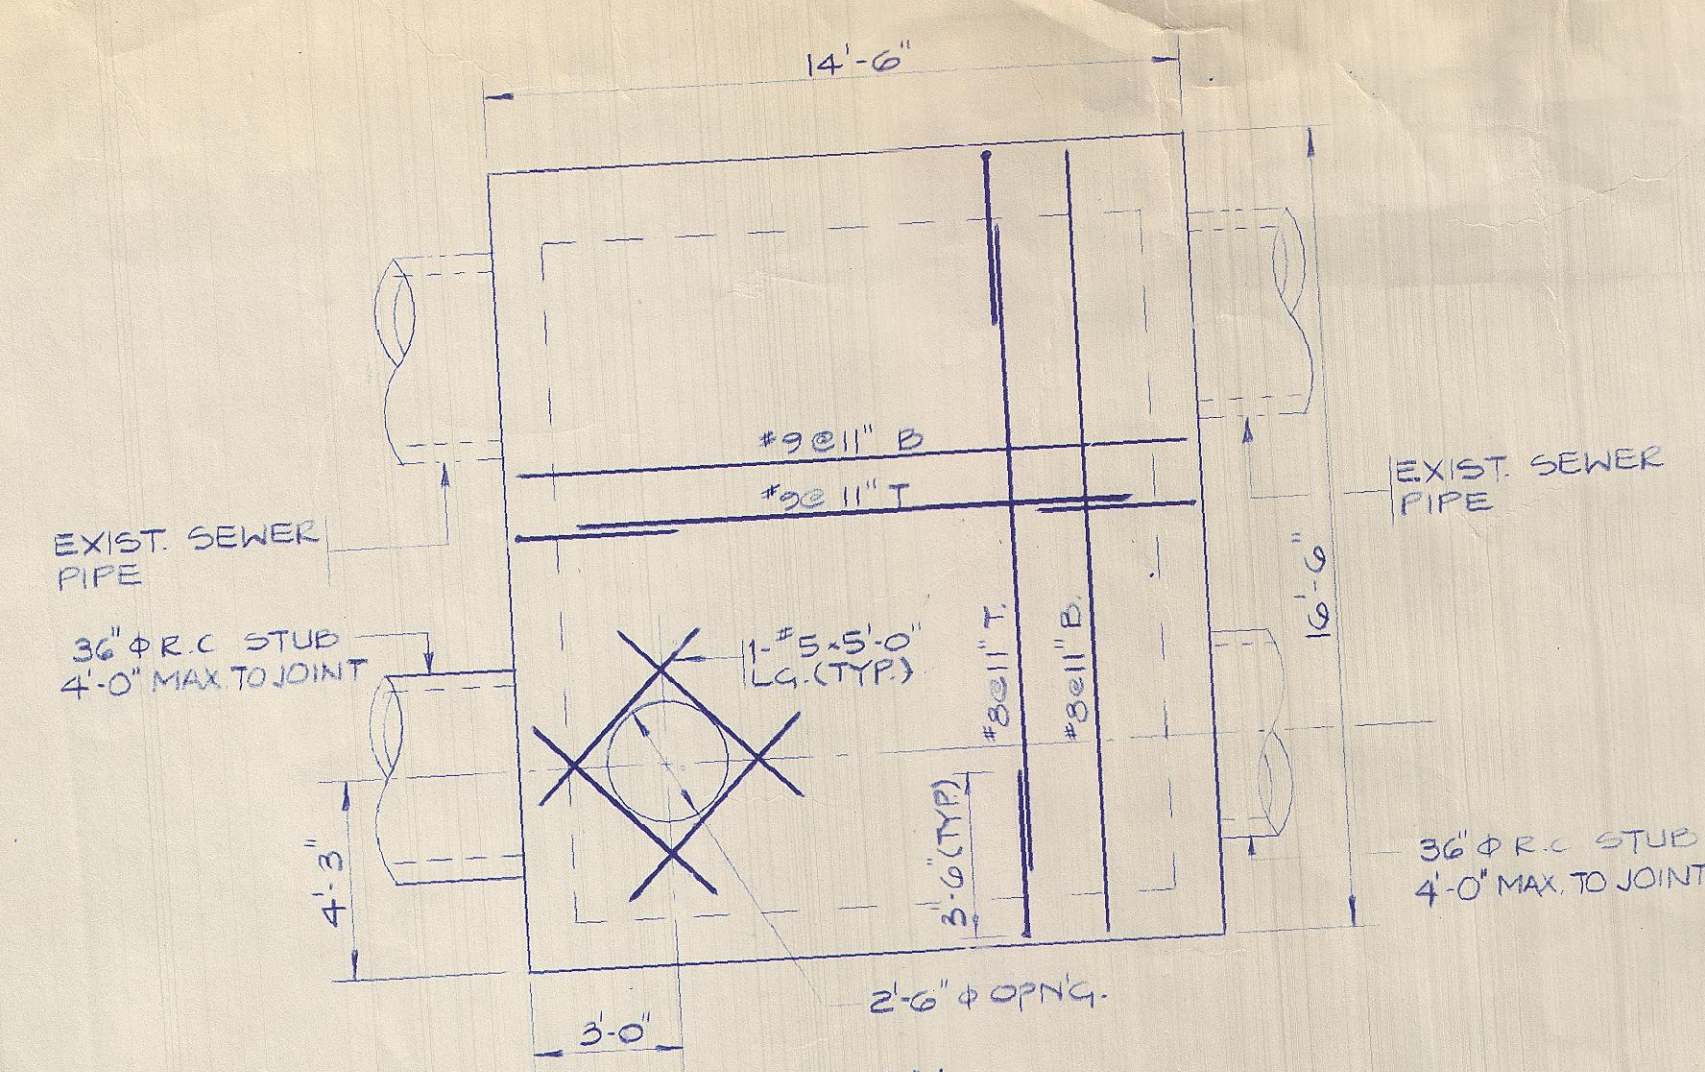

ROOF PLAN
NTS

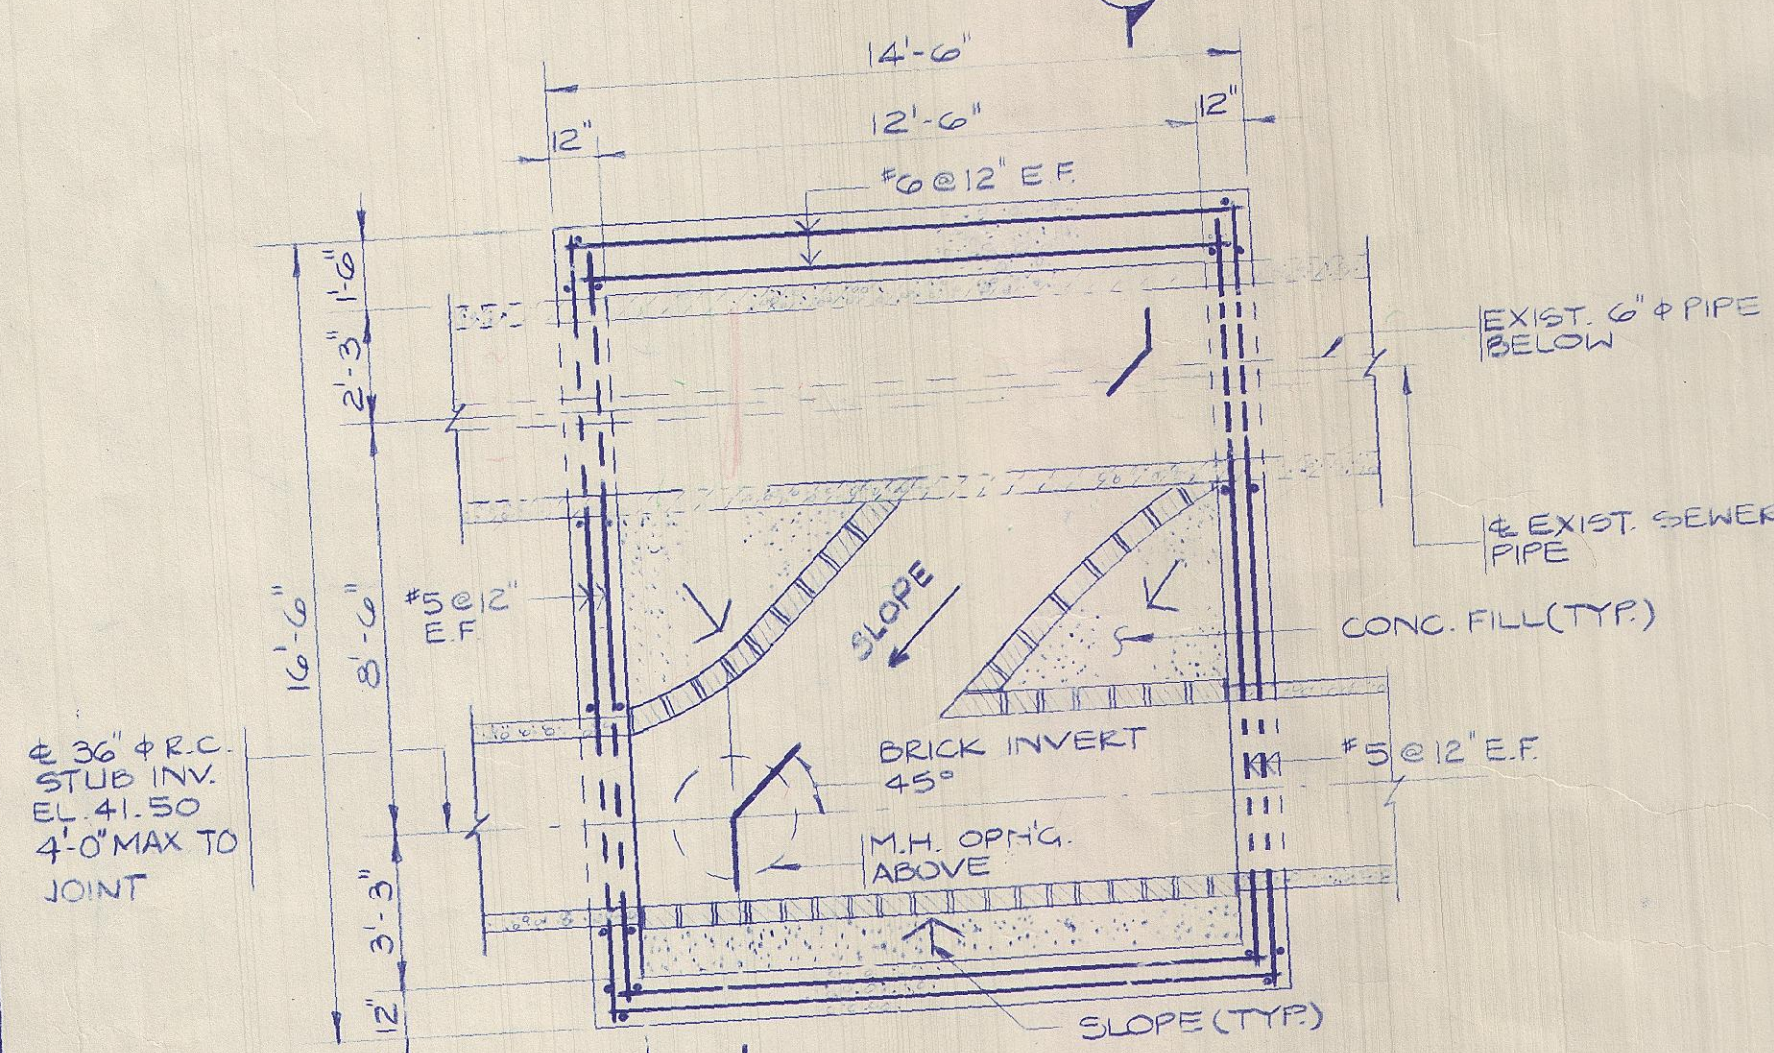


SECTIONAL PLAN
NTS

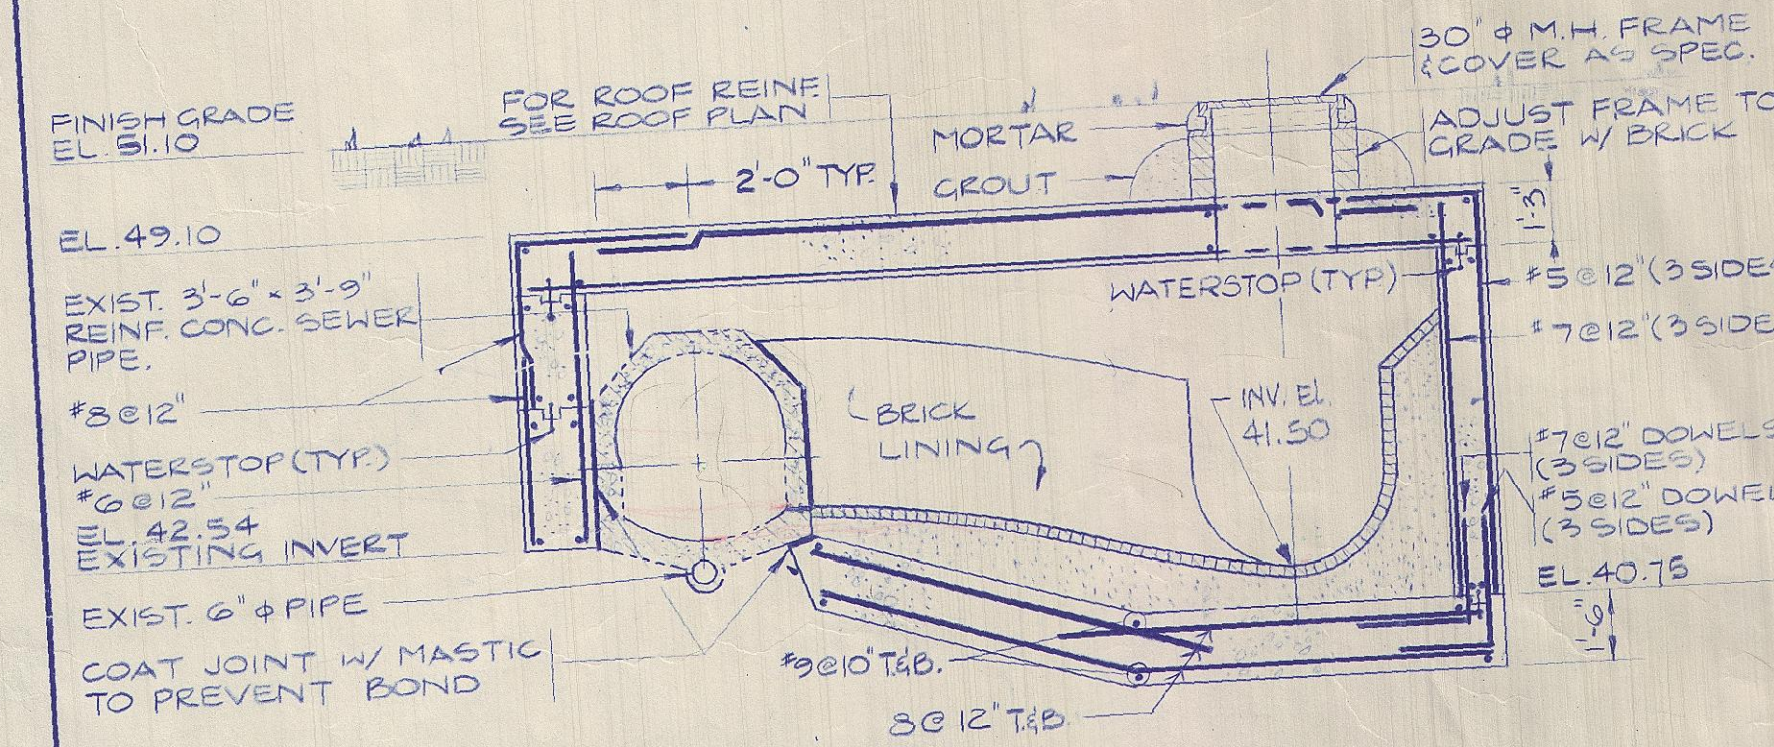


SECTION (B)
NTS


SPECIAL STRUCTURE STA. 70+22

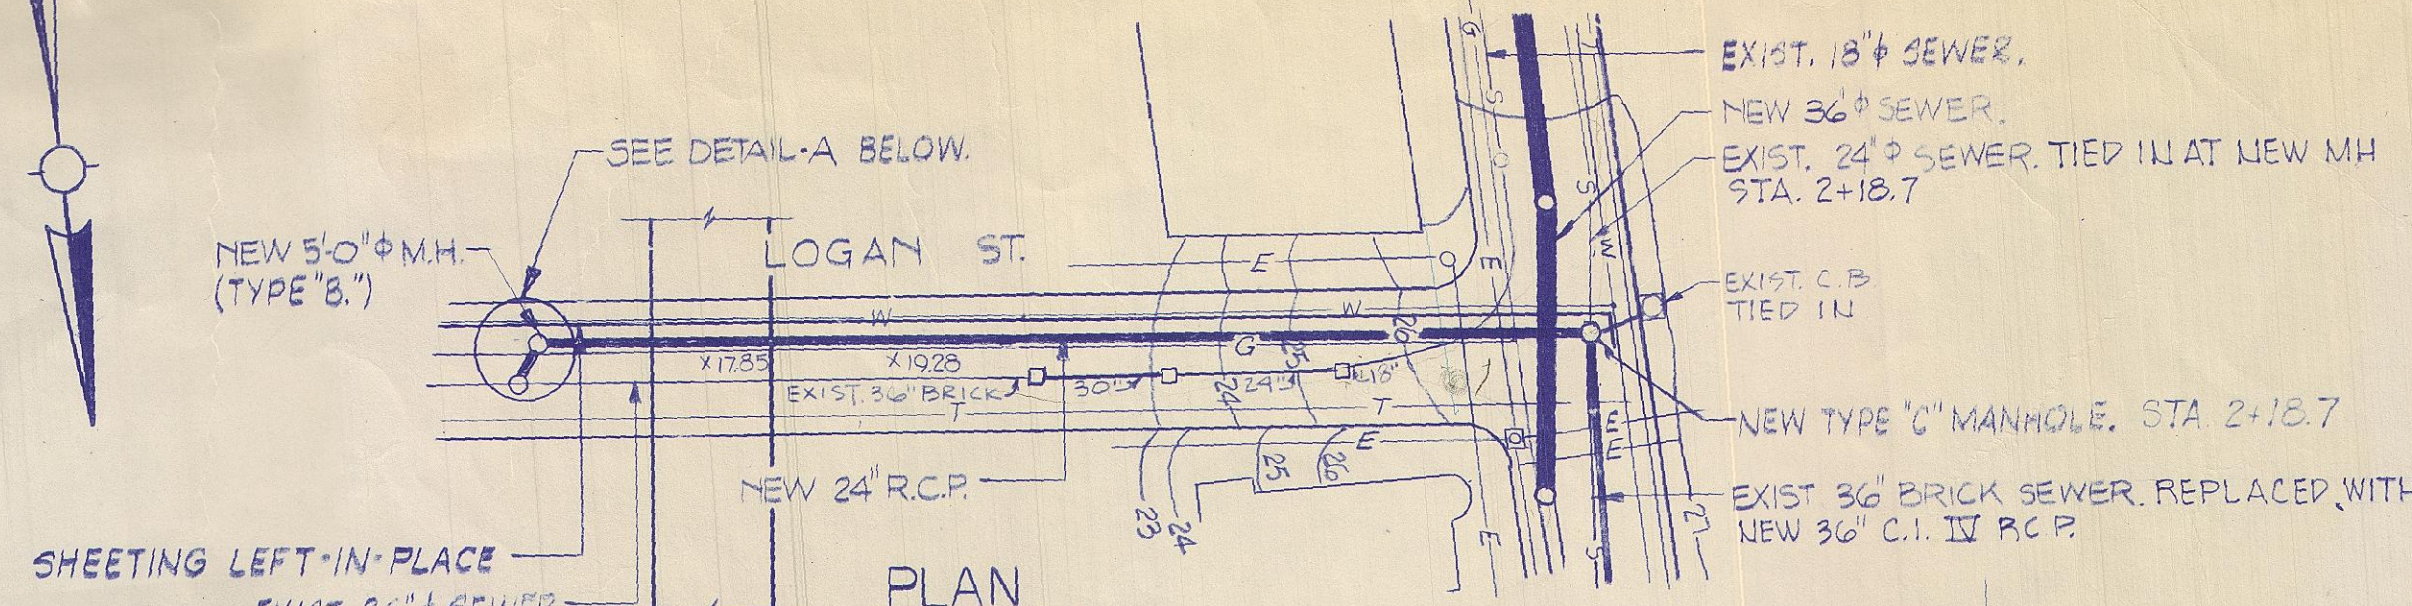


PLAN
SCALE: 1"=40'-0"

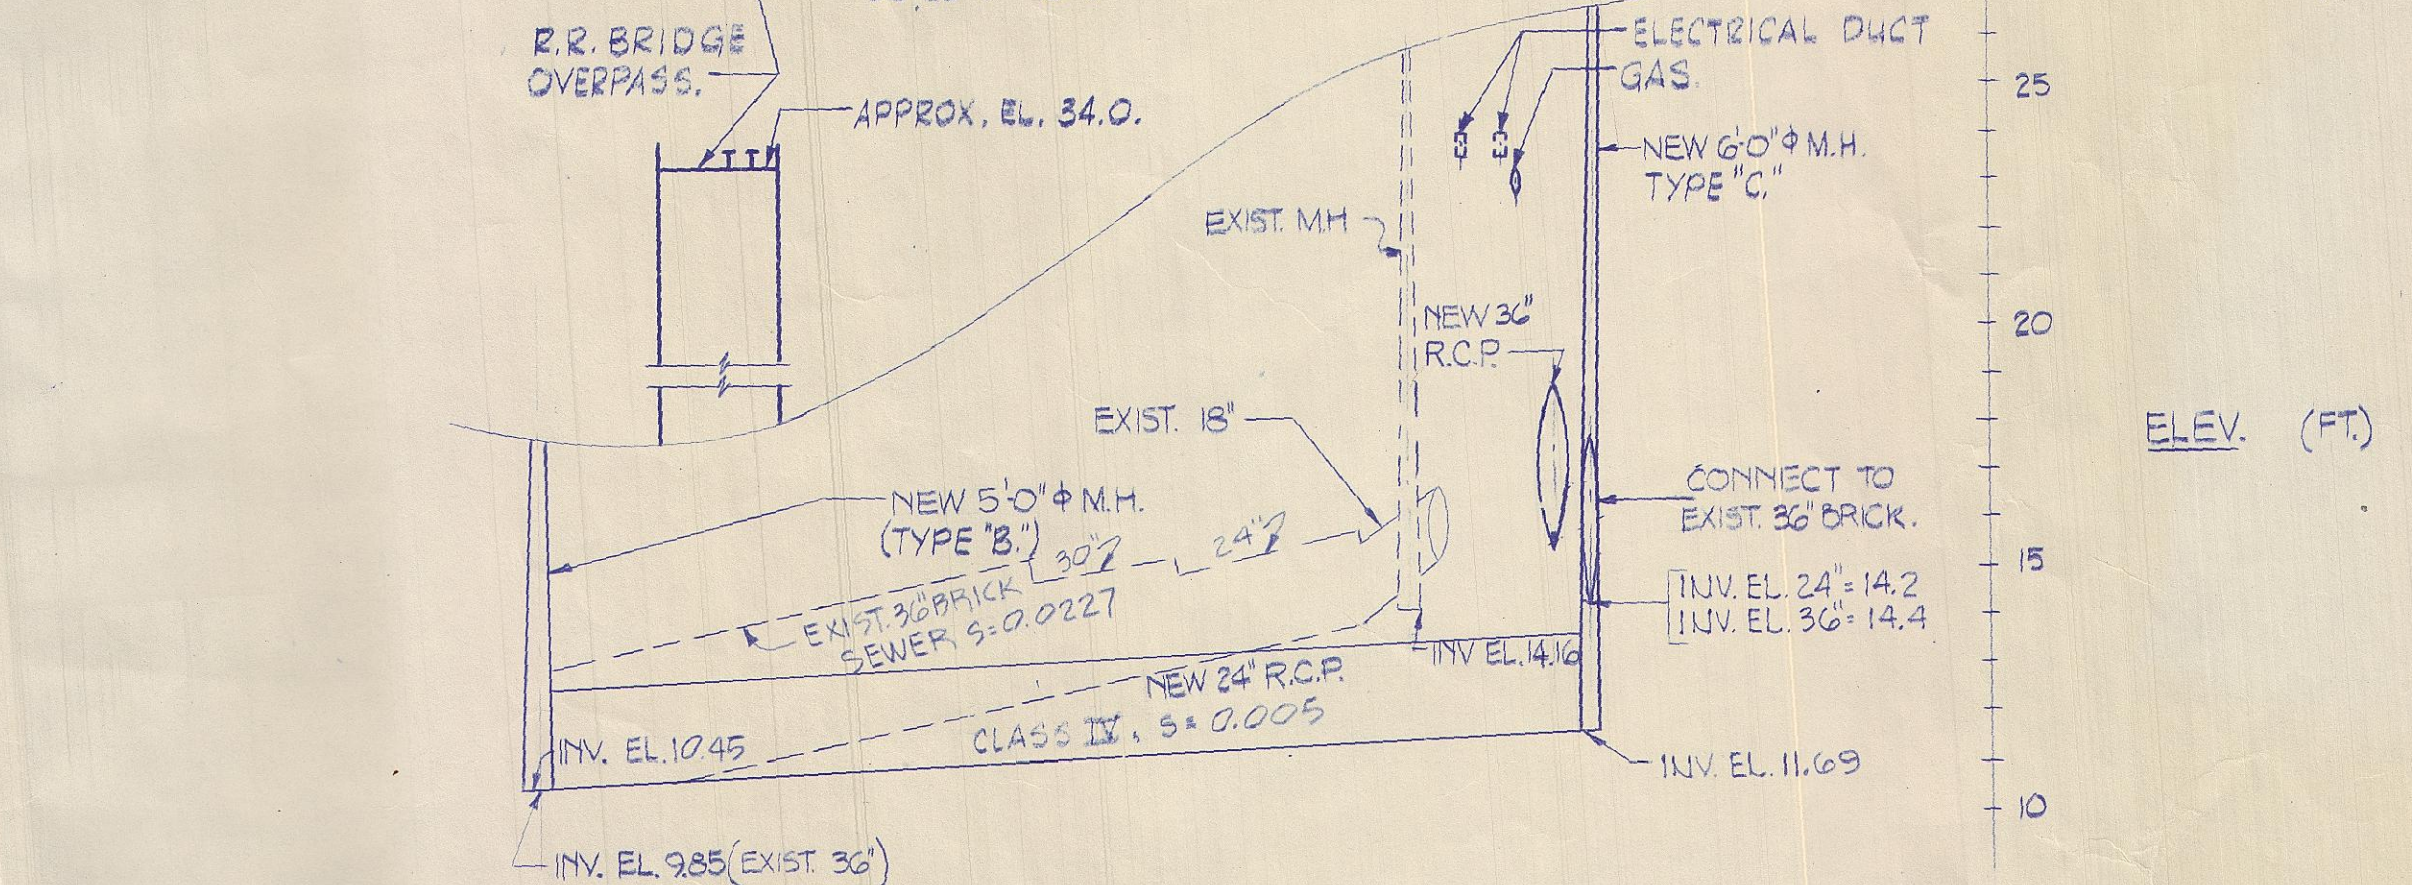

LOGAN STREET PROFILE
SCALE: HOR. 1"=40'-0" VERT. 1"=4'-0"

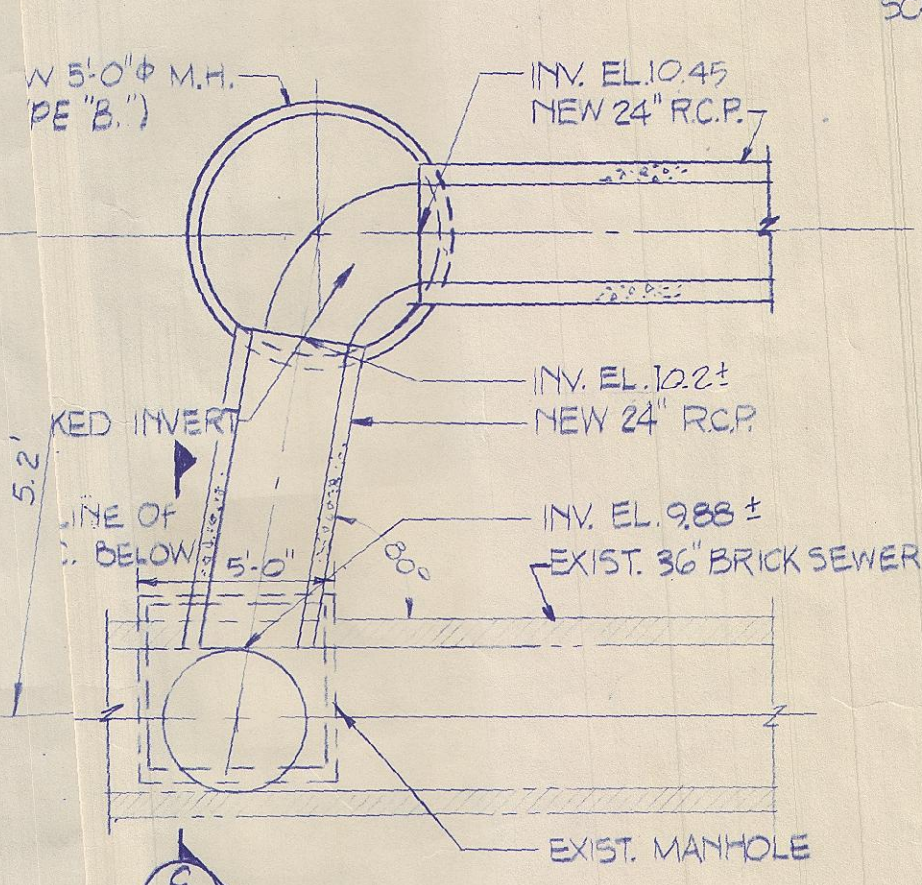

DETAIL - A
SCALE: 1"=4'-0"

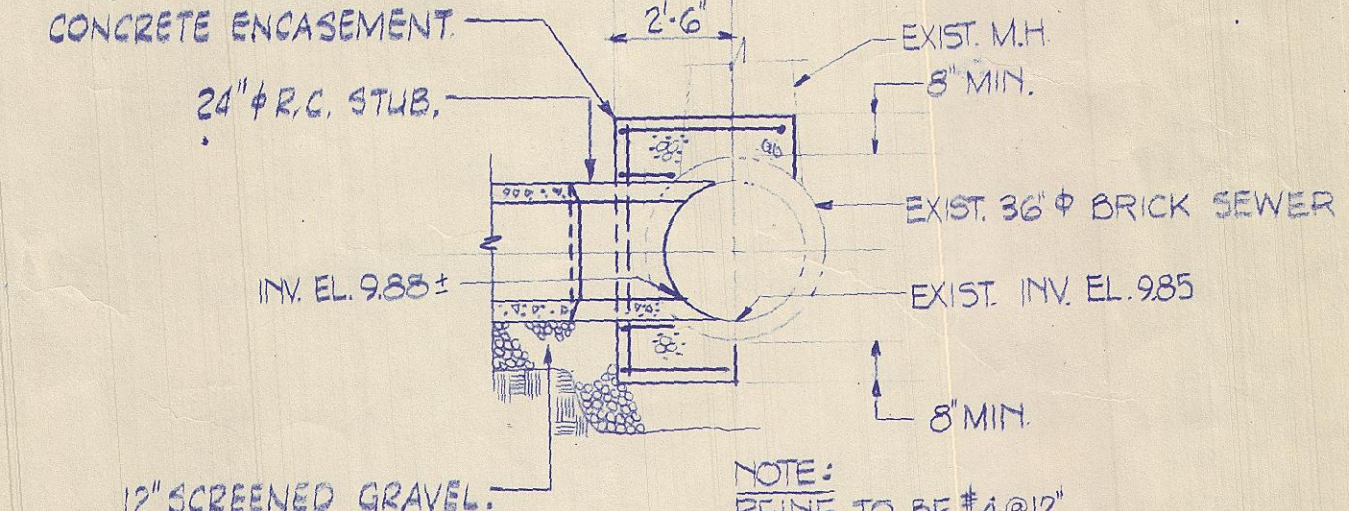

SECTION (C)
SCALE: 1"=4'-0"

RECORD DRAWING

10/9/83	W.J.G.	AS-BUILT
Date	Ch'kd.	Revision
Designed by:	TJQ/RE	
Drawn by:	TFC	Date: December, 1976
Checked by:	TJQ	Scale: As noted.
Approved by:	ZCM	



CITY OF NEW BEDFORD, MASSACHUSETTS
DEPARTMENT OF PUBLIC WORKS
WATER POLLUTION ABATEMENT FACILITIES
NORTH END INTERCEPTOR RELIEF SEWER
PROJECT NO. B-21

**SPECIAL STRUCTURE DETAILS
AND LOGAN STREET SEWER**

CAMP DRESSER & McKEE Inc.
Consulting Engineers
Boston, Mass.

SHEET NO.
21