

SERVICE

34039

NEW BEDFORD WATER WORKS

APPLICATION FOR SERVICE AND METER

NEW BEDFORD

expires 3-7-20

I HEREBY ACKNOWLEDGE the receipt of a copy of the Regulations prescribed in the Ordinance of the City, for the use of Water, and I request that the water may be furnished through a

1" inch copper meter at Marlboro St from Purchase St to Jfk Highway (Pump Station)

at such rates as may from time to time be established by the City.

I hereby agree to pay promptly the bill for the Service pipe laid down for my premises, and to pay all dues for water, and I agree to conform to the said Regulations and to all provisions of the Water Ordinances, until written notice is given by me or my agent to cut off the supply.

TELEPHONE (508) 979-1330

Manuel H. Silva
City of NB wastewater
1105 Shawmut Ave
NB MA 02746

Service laid _____ Size and kind of pipe _____

From *work to be done in accordance to city contract

Turned on See attached Plans Meter Set _____

Reading _____ Location _____

Building rates _____

Cost of Service NA city Project

31-727


Paid Neil Schwartz (Prior Manager)

Paid WES Construction Corp
650 Industrial Dr. Hattax MA 02338

S x N Line Merrimac St 20.0'
N x S Line Merrimac St 30.0'
E x W Line Purchase St 19.0'
4" Gas main 2" North x Gate Valve

6-4-2019: New 8" DI installed by
WES Construction, Inspector
Manuekl Rose


REFERENCES: [CDMS_2436, C001EXWP, Merrimac\DesignBase] Images: [DLM Stamp 03162018]
 last saved by: LAUZONCE Time: 3/16/2018 2:36:51 PM
 \\pwp_pl1\lauzonce\d0705851\CSTPL002.dwg

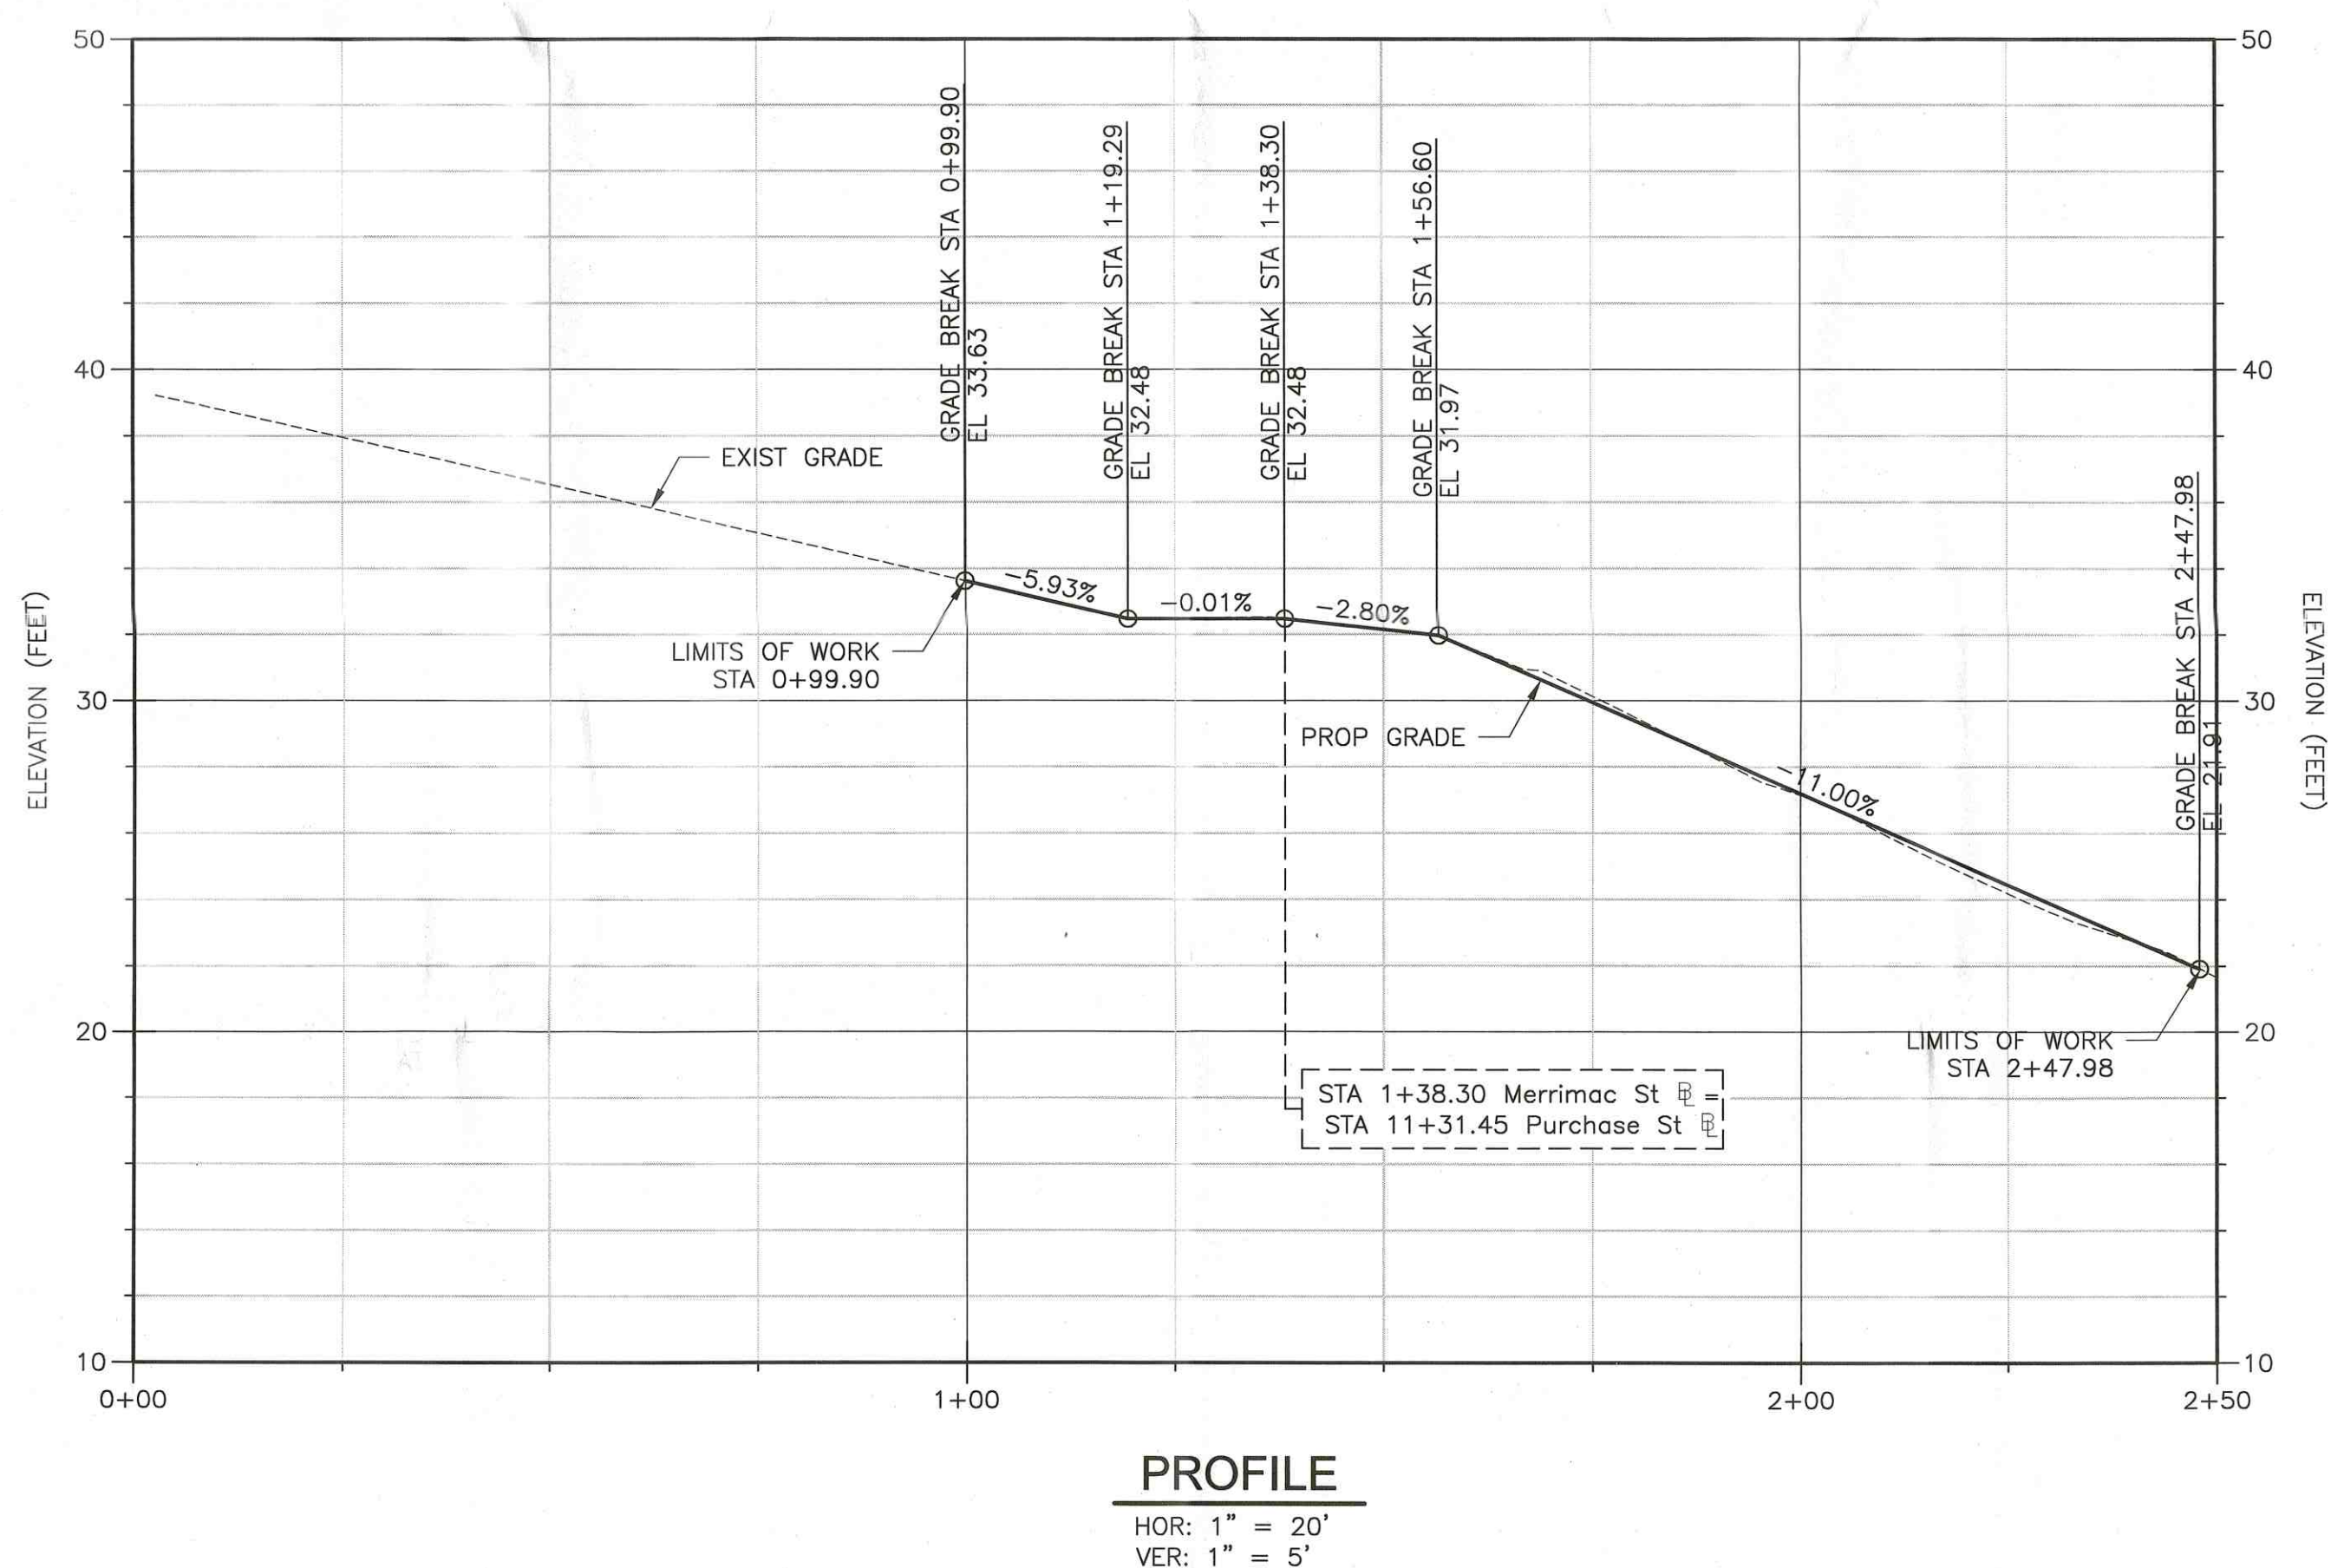

					DESIGNED BY: <u>C. LAUZON</u>	 260 West Exchange Street, Suite 300 Providence, RI 02903 Tel: (401) 751-5360	CITY OF NEW BEDFORD, MASSACHUSETTS WASTEWATER SYSTEM IMPROVEMENTS			PROJECT NO. 0309-219437		
					DRAWN BY: <u>C. LAUZON</u>		FRONT STREET PUMPING STATION AND			FILE NAME: CSTPL002.DWG		
					SHEET CHK'D BY: <u>D. L. MURPHY</u>		MERRIMAC STREET PUMPING STATION			SHEET NO.		
					CROSS CHK'D BY: <u>S. SYDE</u>		REHABILITATION PROJECT			C-11		
					APPROVED BY: <u>D. L. MURPHY</u>							
REV. NO.	DATE	DRWN	CHKD	REMARKS	DATE: <u>MARCH 2018</u>							


CONFORMED DRAWING

XREFs: [CDMS_21936_CDDT_EWP_MerrimacStDesignBase] Images: []
Drawn by: [CDMS_21936_CDDT_EWP_MerrimacStDesignBase]
Checked by: [CDMS_21936_CDDT_EWP_MerrimacStDesignBase]
© 2018 CDM SMITH. ALL RIGHTS RESERVED.
REUSE OF DOCUMENTS: THESE DOCUMENTS AND DESIGNS PROVIDED BY PROFESSIONAL SERVICE, INCORPORATED HEREIN, ARE THE PROPERTY OF CDM SMITH AND ARE NOT TO BE USED, IN WHOLE OR PART, FOR ANY OTHER PROJECT WITHOUT THE WRITTEN AUTHORIZATION OF CDM SMITH.

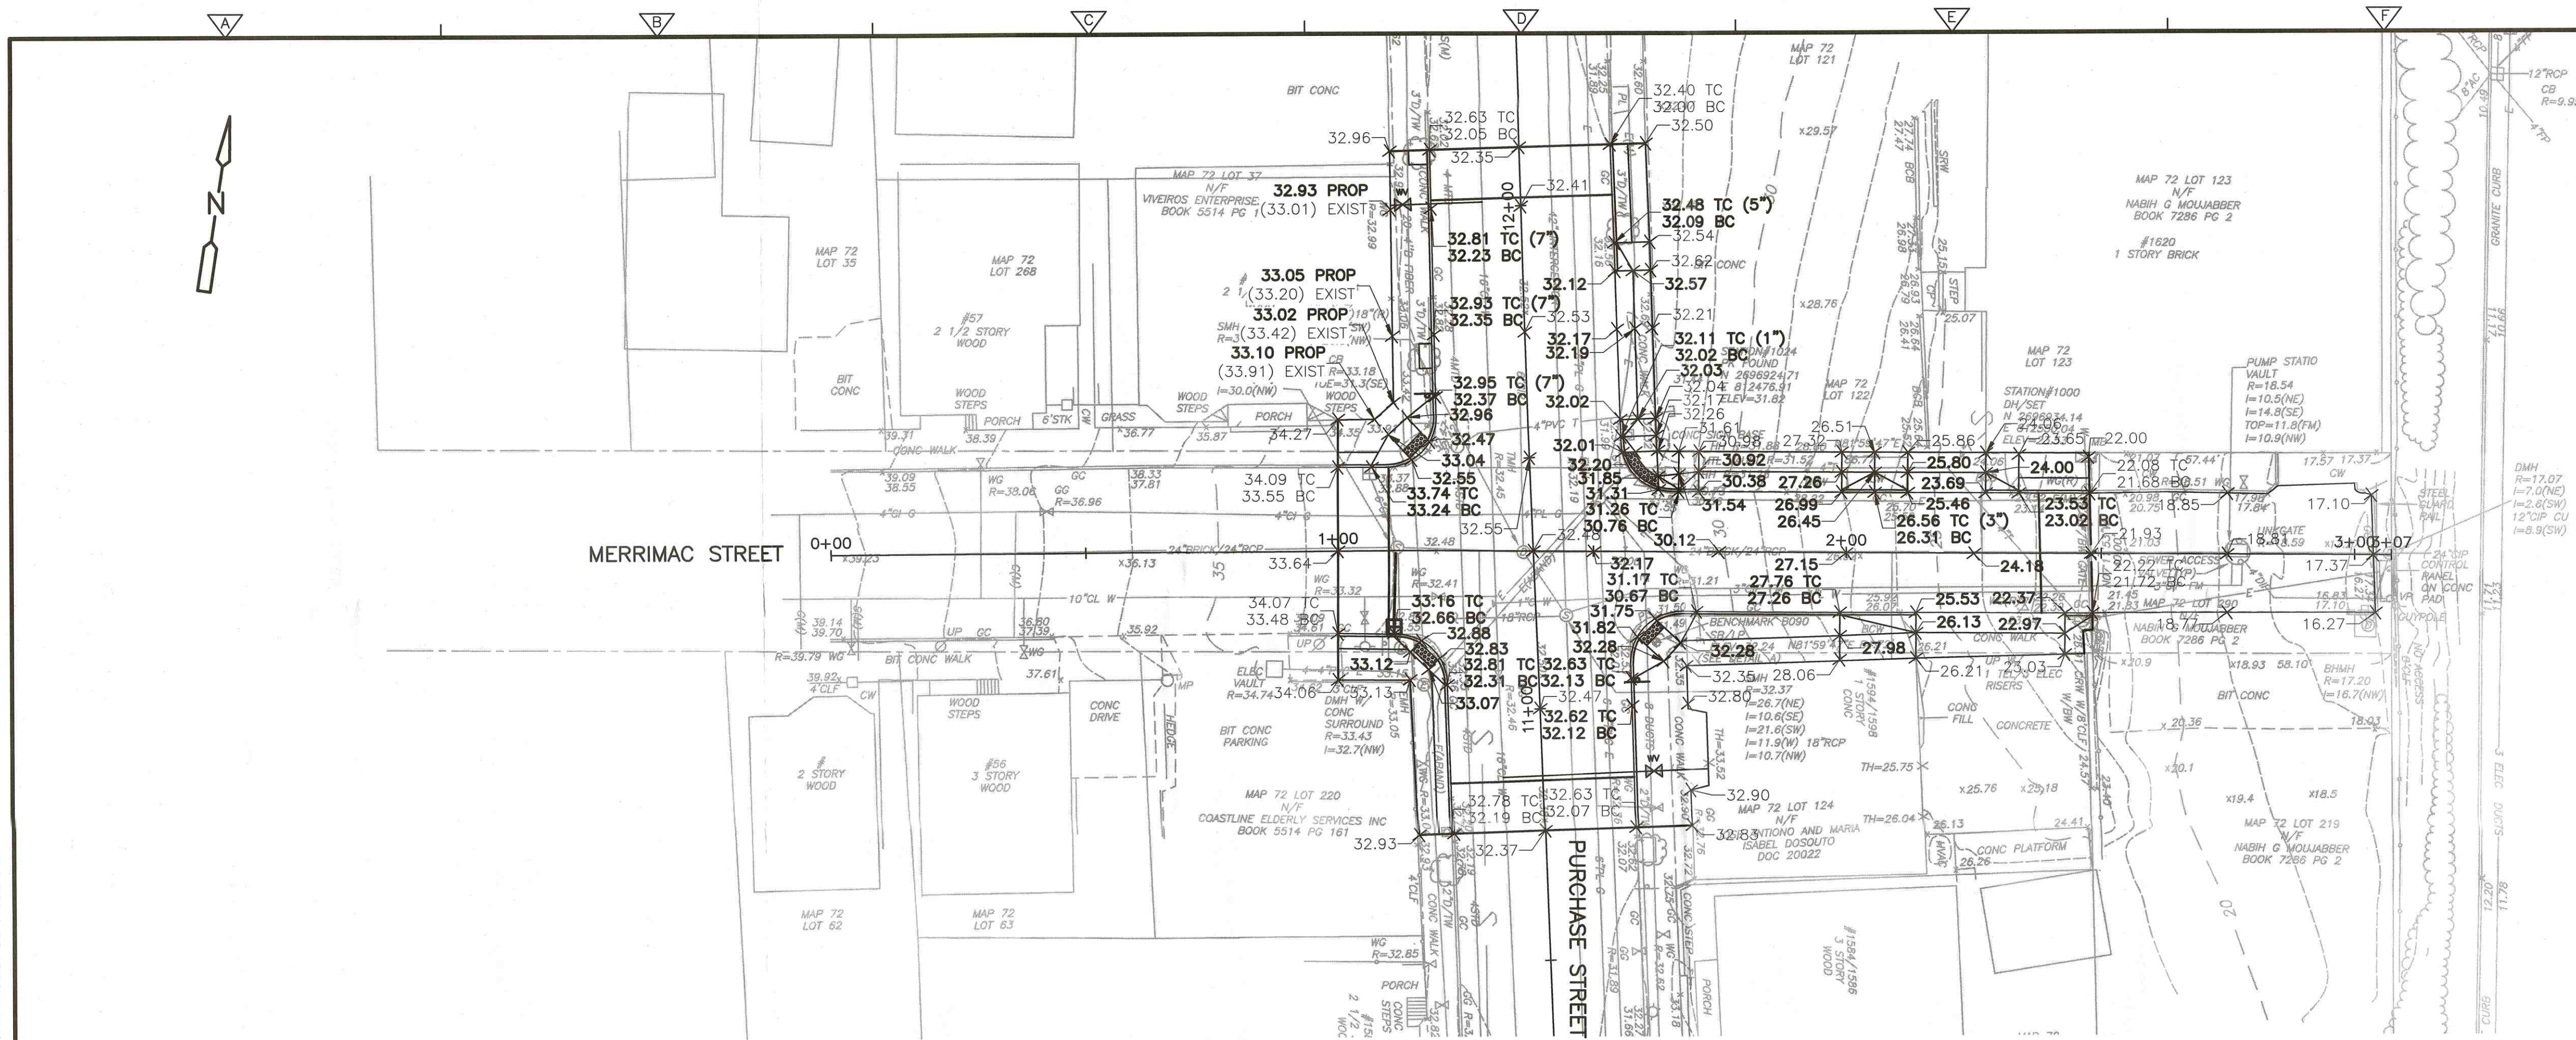

GRADING PLAN

1" = 20'

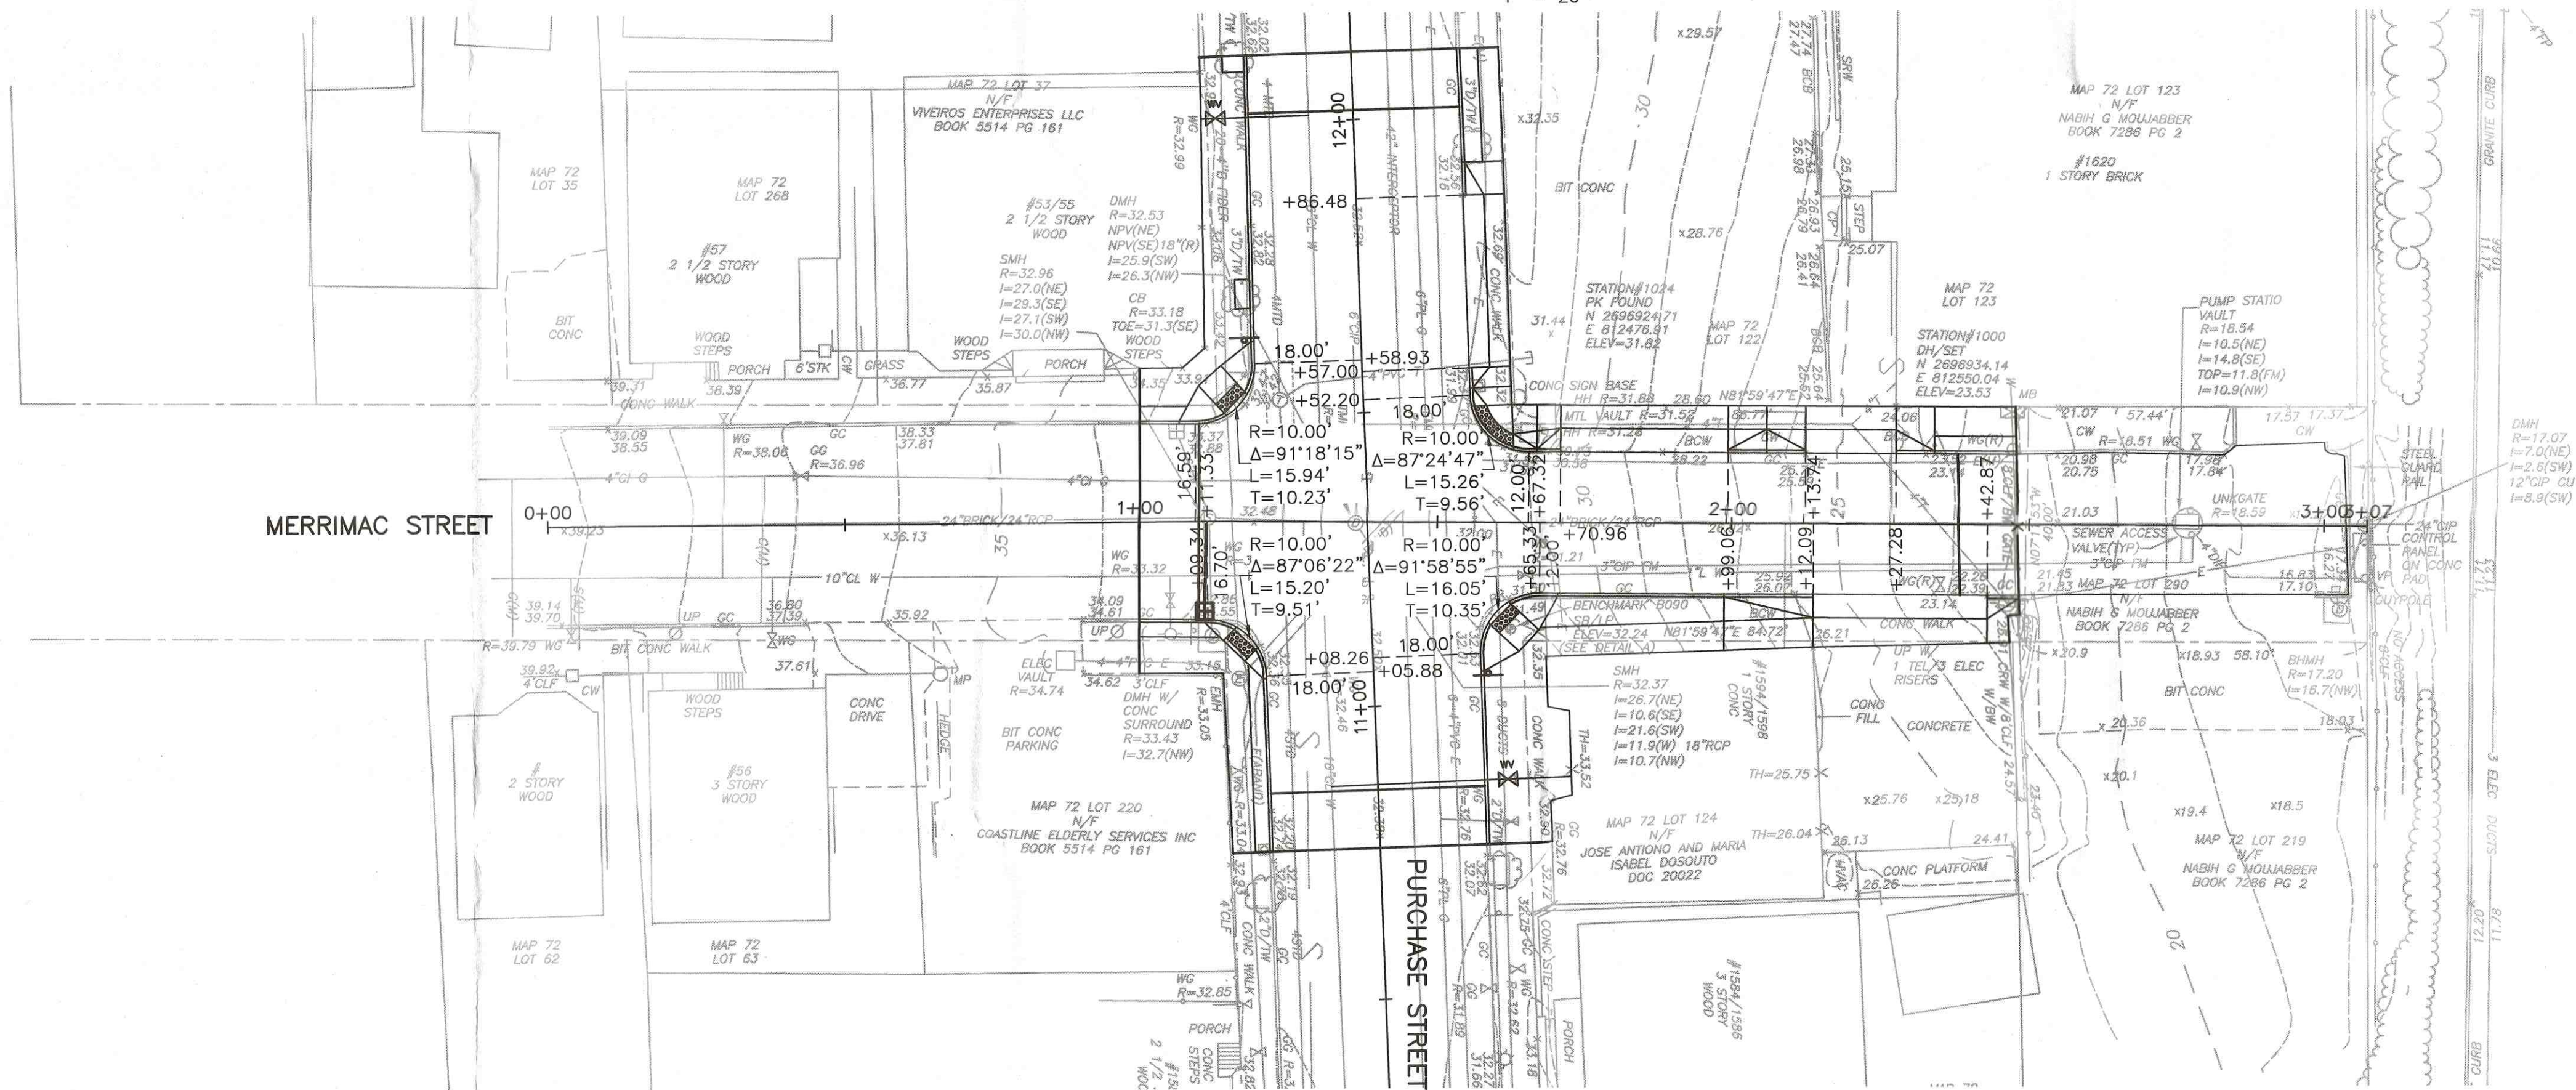

CURB TIE PLAN

1" = 20'

- NOTES
1. WHEELCHAIR RAMPS SHALL BE CONSTRUCTED CONSISTENT WITH MASSDOT CONSTRUCTION STANDARDS.
 2. COBBLES ENCOUNTERED AND REMOVED DURING EXCAVATION SHALL BE DELIVERED TO DPI.
 3. CURBING REMOVED AND SUITABLE SHALL BE DELIVERED TO DPI.

1" = 20'
10 0 20

REV. NO.	DATE	DRWN	CHKD	REMARKS

DESIGNED BY: C. LAUZON
DRAWN BY: C. LAUZON
SHEET CHK'D BY: D. L. MURPHY
CROSS CHK'D BY: S. SYDE
APPROVED BY: D. L. MURPHY
DATE: MARCH 2018

CDM Smith
200 West Exchange Street, Suite 300
Providence, RI 02903
Tel: (401) 781-0380



CITY OF NEW BEDFORD, MASSACHUSETTS
WASTEWATER SYSTEM IMPROVEMENTS
FRONT STREET PUMPING STATION AND
MERRIMAC STREET PUMPING STATION
REHABILITATION PROJECT

MERRIMAC STREET
CURB TIE AND GRADING PLANS

PROJECT NO. 0309-219437
FILE NAME: CSTPL002.DWG
SHEET NO.
C-12

CONFORMED DRAWING

XREFs: [CDMS_2436_C001EXP_C004CSWP] Images: []
p:\projects\newbedford\c001exp\c004cswp\p01\0309\219437\04 Design Services NM_Addendum\02 CHN\10 CAD\0010PSP.dwg
© 2018 CDM SMITH ALL RIGHTS RESERVED.
REUSE OF DOCUMENTS: THESE DOCUMENTS AND DESIGNS PROVIDED BY PROFESSIONAL SERVICE, INCORPORATED HEREIN, ARE THE PROPERTY OF CDM SMITH AND ARE NOT TO BE USED, IN WHOLE OR PART, FOR ANY OTHER PROJECT WITHOUT THE WRITTEN AUTHORIZATION OF CDM SMITH.

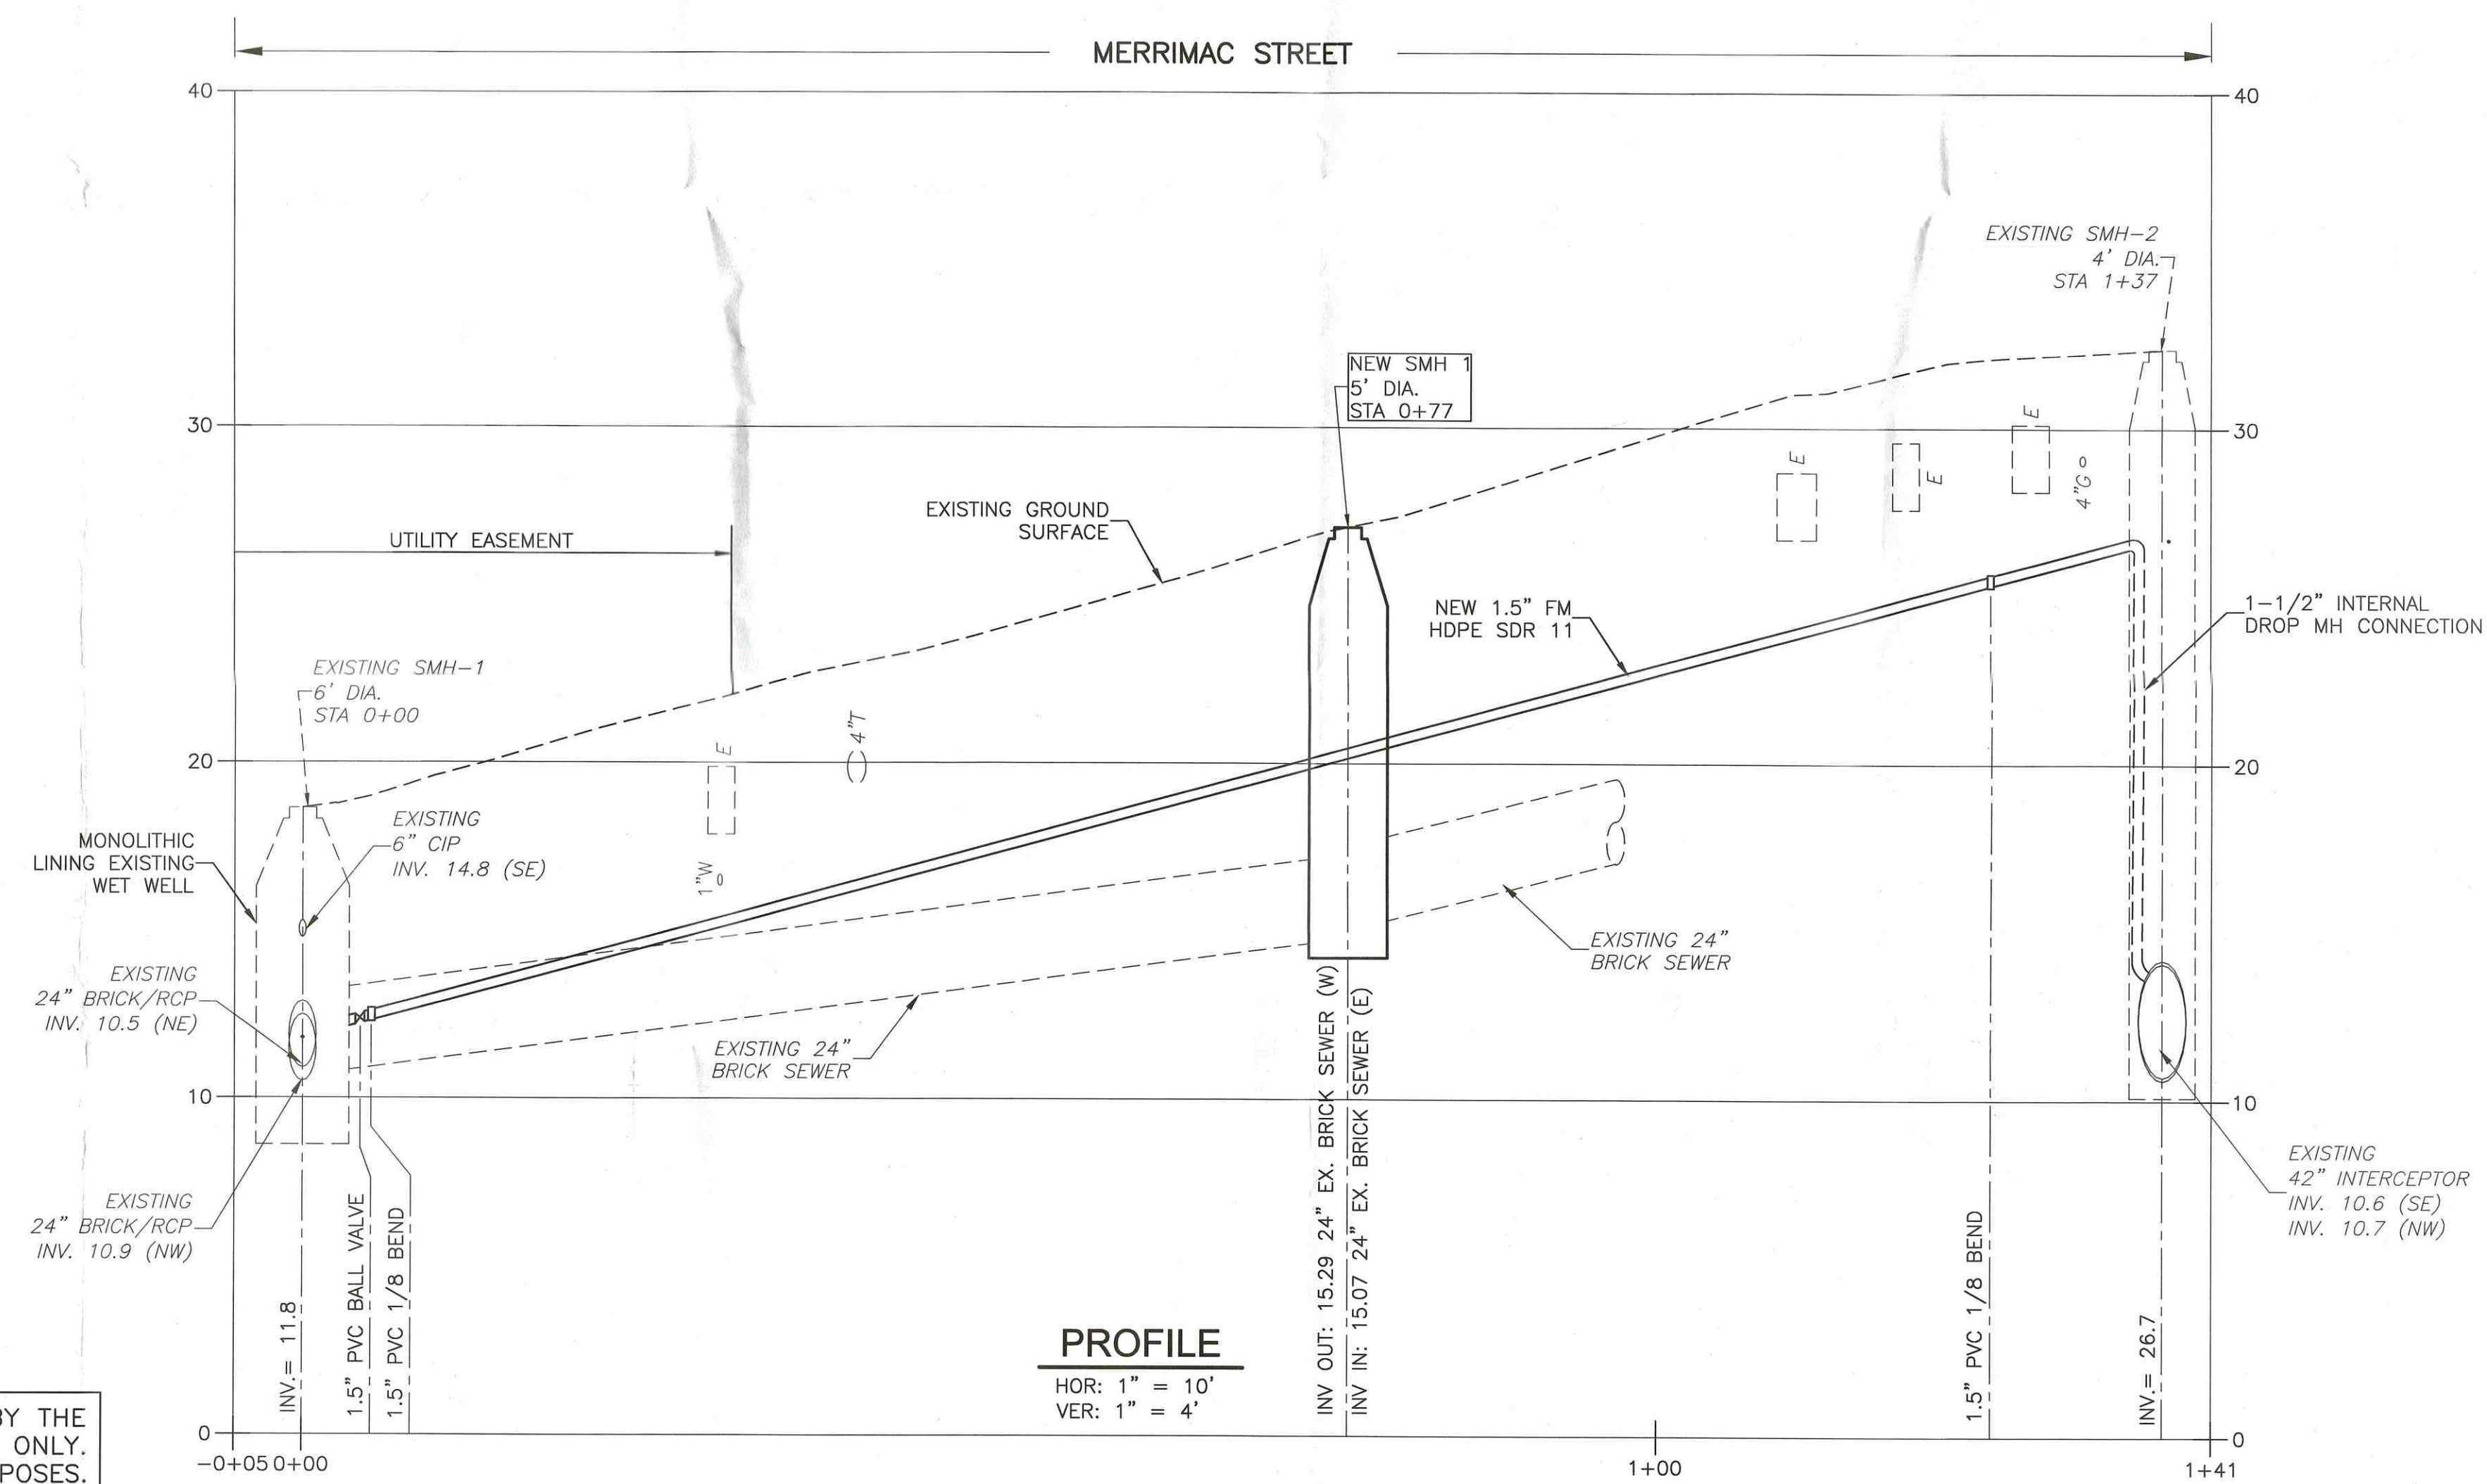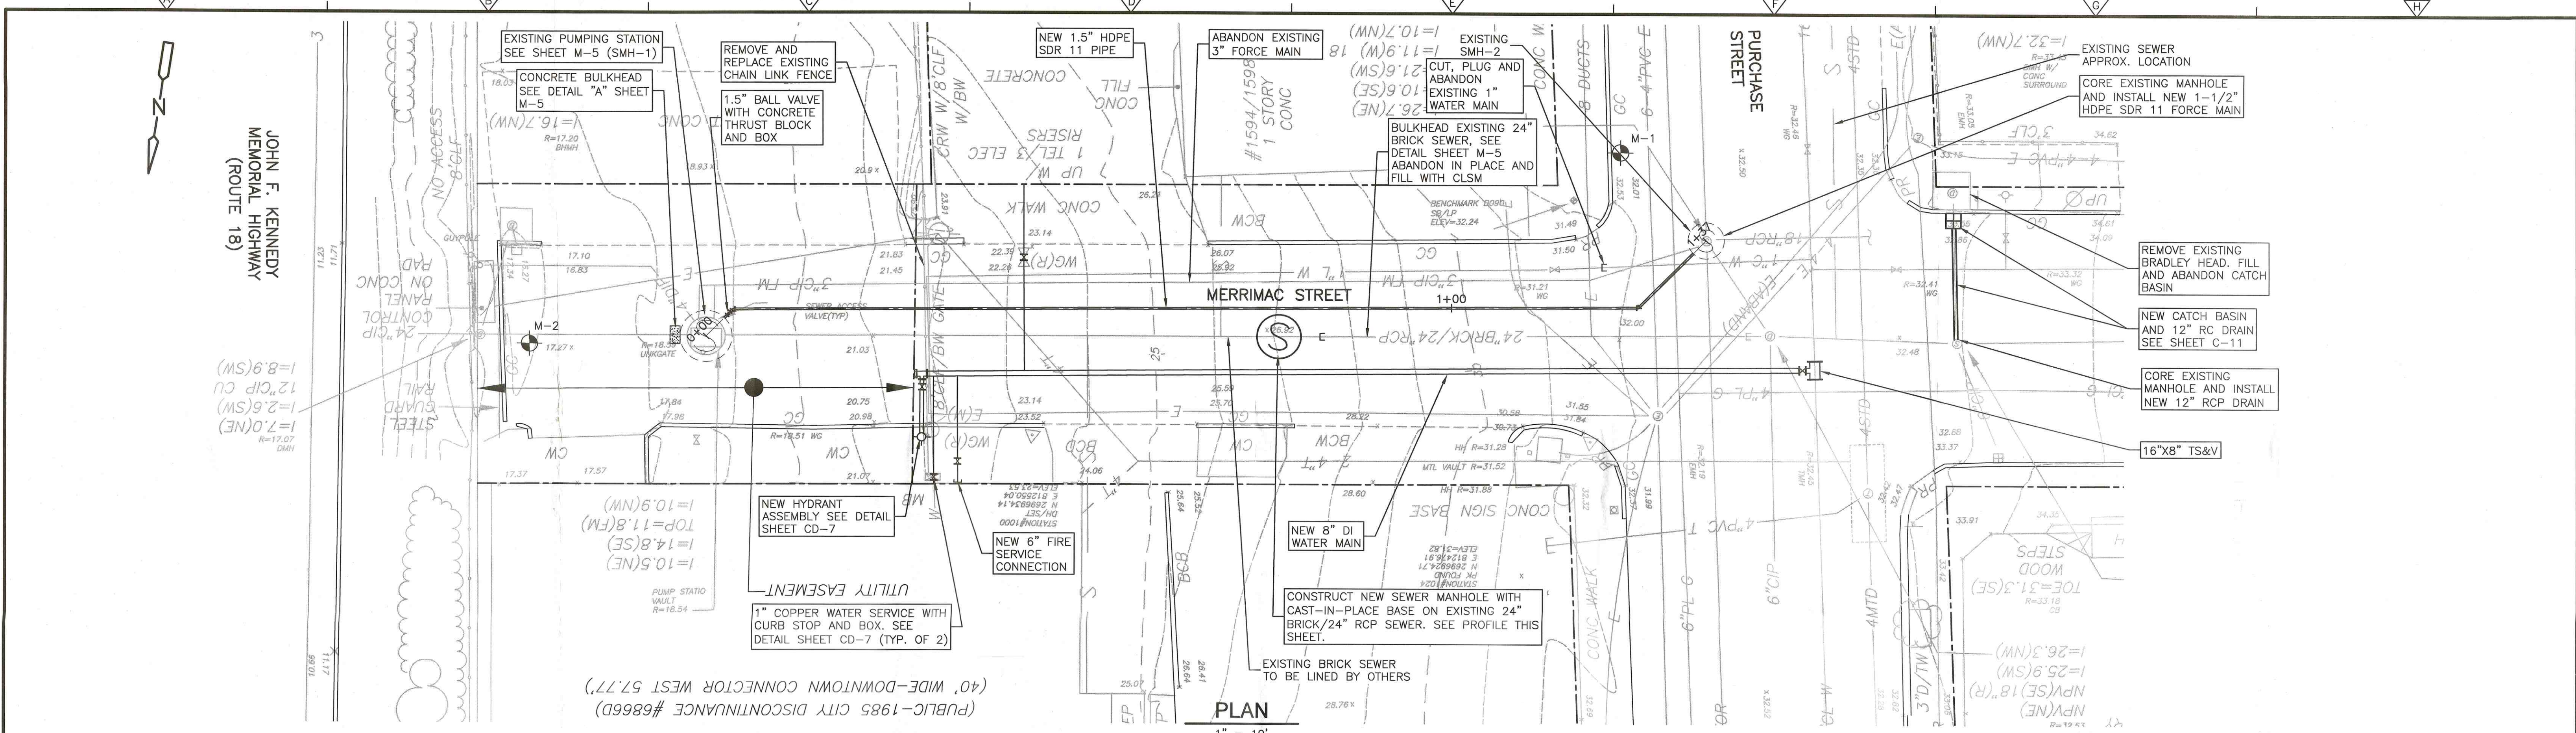

- NOTES:
- SEE SHEETS C-11 THRU C-13 FOR ROADWAY RECONSTRUCTION WORK.
 - SEE APPENDIX A OF VOLUME 3 OF SPECIFICATIONS FOR BORING LOGS FOR M-1 AND M-2.
 - CONFIRM ALL SEWER SERVICE LOCATIONS VIA INTERNAL CCTV INSPECTION AND DYE TESTING.

UNOFFICIAL CONFORMED CONTRACT DRAWINGS ARE FOR USE BY THE CITY OF NEW BEDFORD DPI CONSTRUCTION MANAGEMENT STAFF ONLY. THESE DRAWINGS ARE PROVIDED SOLELY FOR INFORMATIONAL PURPOSES.

REV. NO.	DATE	DRWN	CHKD	REMARKS
2	9/18	JW	JH	CONFORMED DRAWING
1	4/26/18	J.J.C.	S.T.S.	CALL OUT REVISION

DESIGNED BY:	S. SYDE
DRAWN BY:	J. CABRERA
SHEET CHK'D BY:	S. SYDE
CROSS CHK'D BY:	R. NORTON
APPROVED BY:	S. SYDE
DATE:	MARCH 2018

CDM Smith
280 West Exchange Street, Suite 300
Providence, RI 02903
Tel: (401) 751-5360



CITY OF NEW BEDFORD, MASSACHUSETTS
WASTEWATER SYSTEM IMPROVEMENTS
FRONT STREET PUMPING STATION AND
MERRIMAC STREET PUMPING STATION
REHABILITATION PROJECT

MERRIMAC STREET PUMPING STATION
GENERAL PLAN AND PROFILE

PROJECT NO.	0309-219437
FILE NAME:	C010PSP.dwg
SHEET NO.	C-10

CONFORMED DRAWING

XREFs: [CDMS_2436, C001EWIP, C004CSWIP] Images: []
Last saved by: WELDONAJ Time: 9/25/2018 2:29:37 PM
pe:\vpc\cdmsmith\com\sw_pl\10309\219437\04 Design Services NM_Addendum\02 Cw\10 CADD\C010PSPL.dwg
REVISED OF DOCUMENTS: THESE DOCUMENTS AND DESIGNS PROVIDED BY PROFESSIONAL SERVICE, INCORPORATED HEREIN, ARE THE PROPERTY OF CDM SMITH AND ARE NOT TO BE USED, IN WHOLE OR PART, FOR ANY OTHER PROJECT WITHOUT THE WRITTEN AUTHORIZATION OF CDM SMITH.

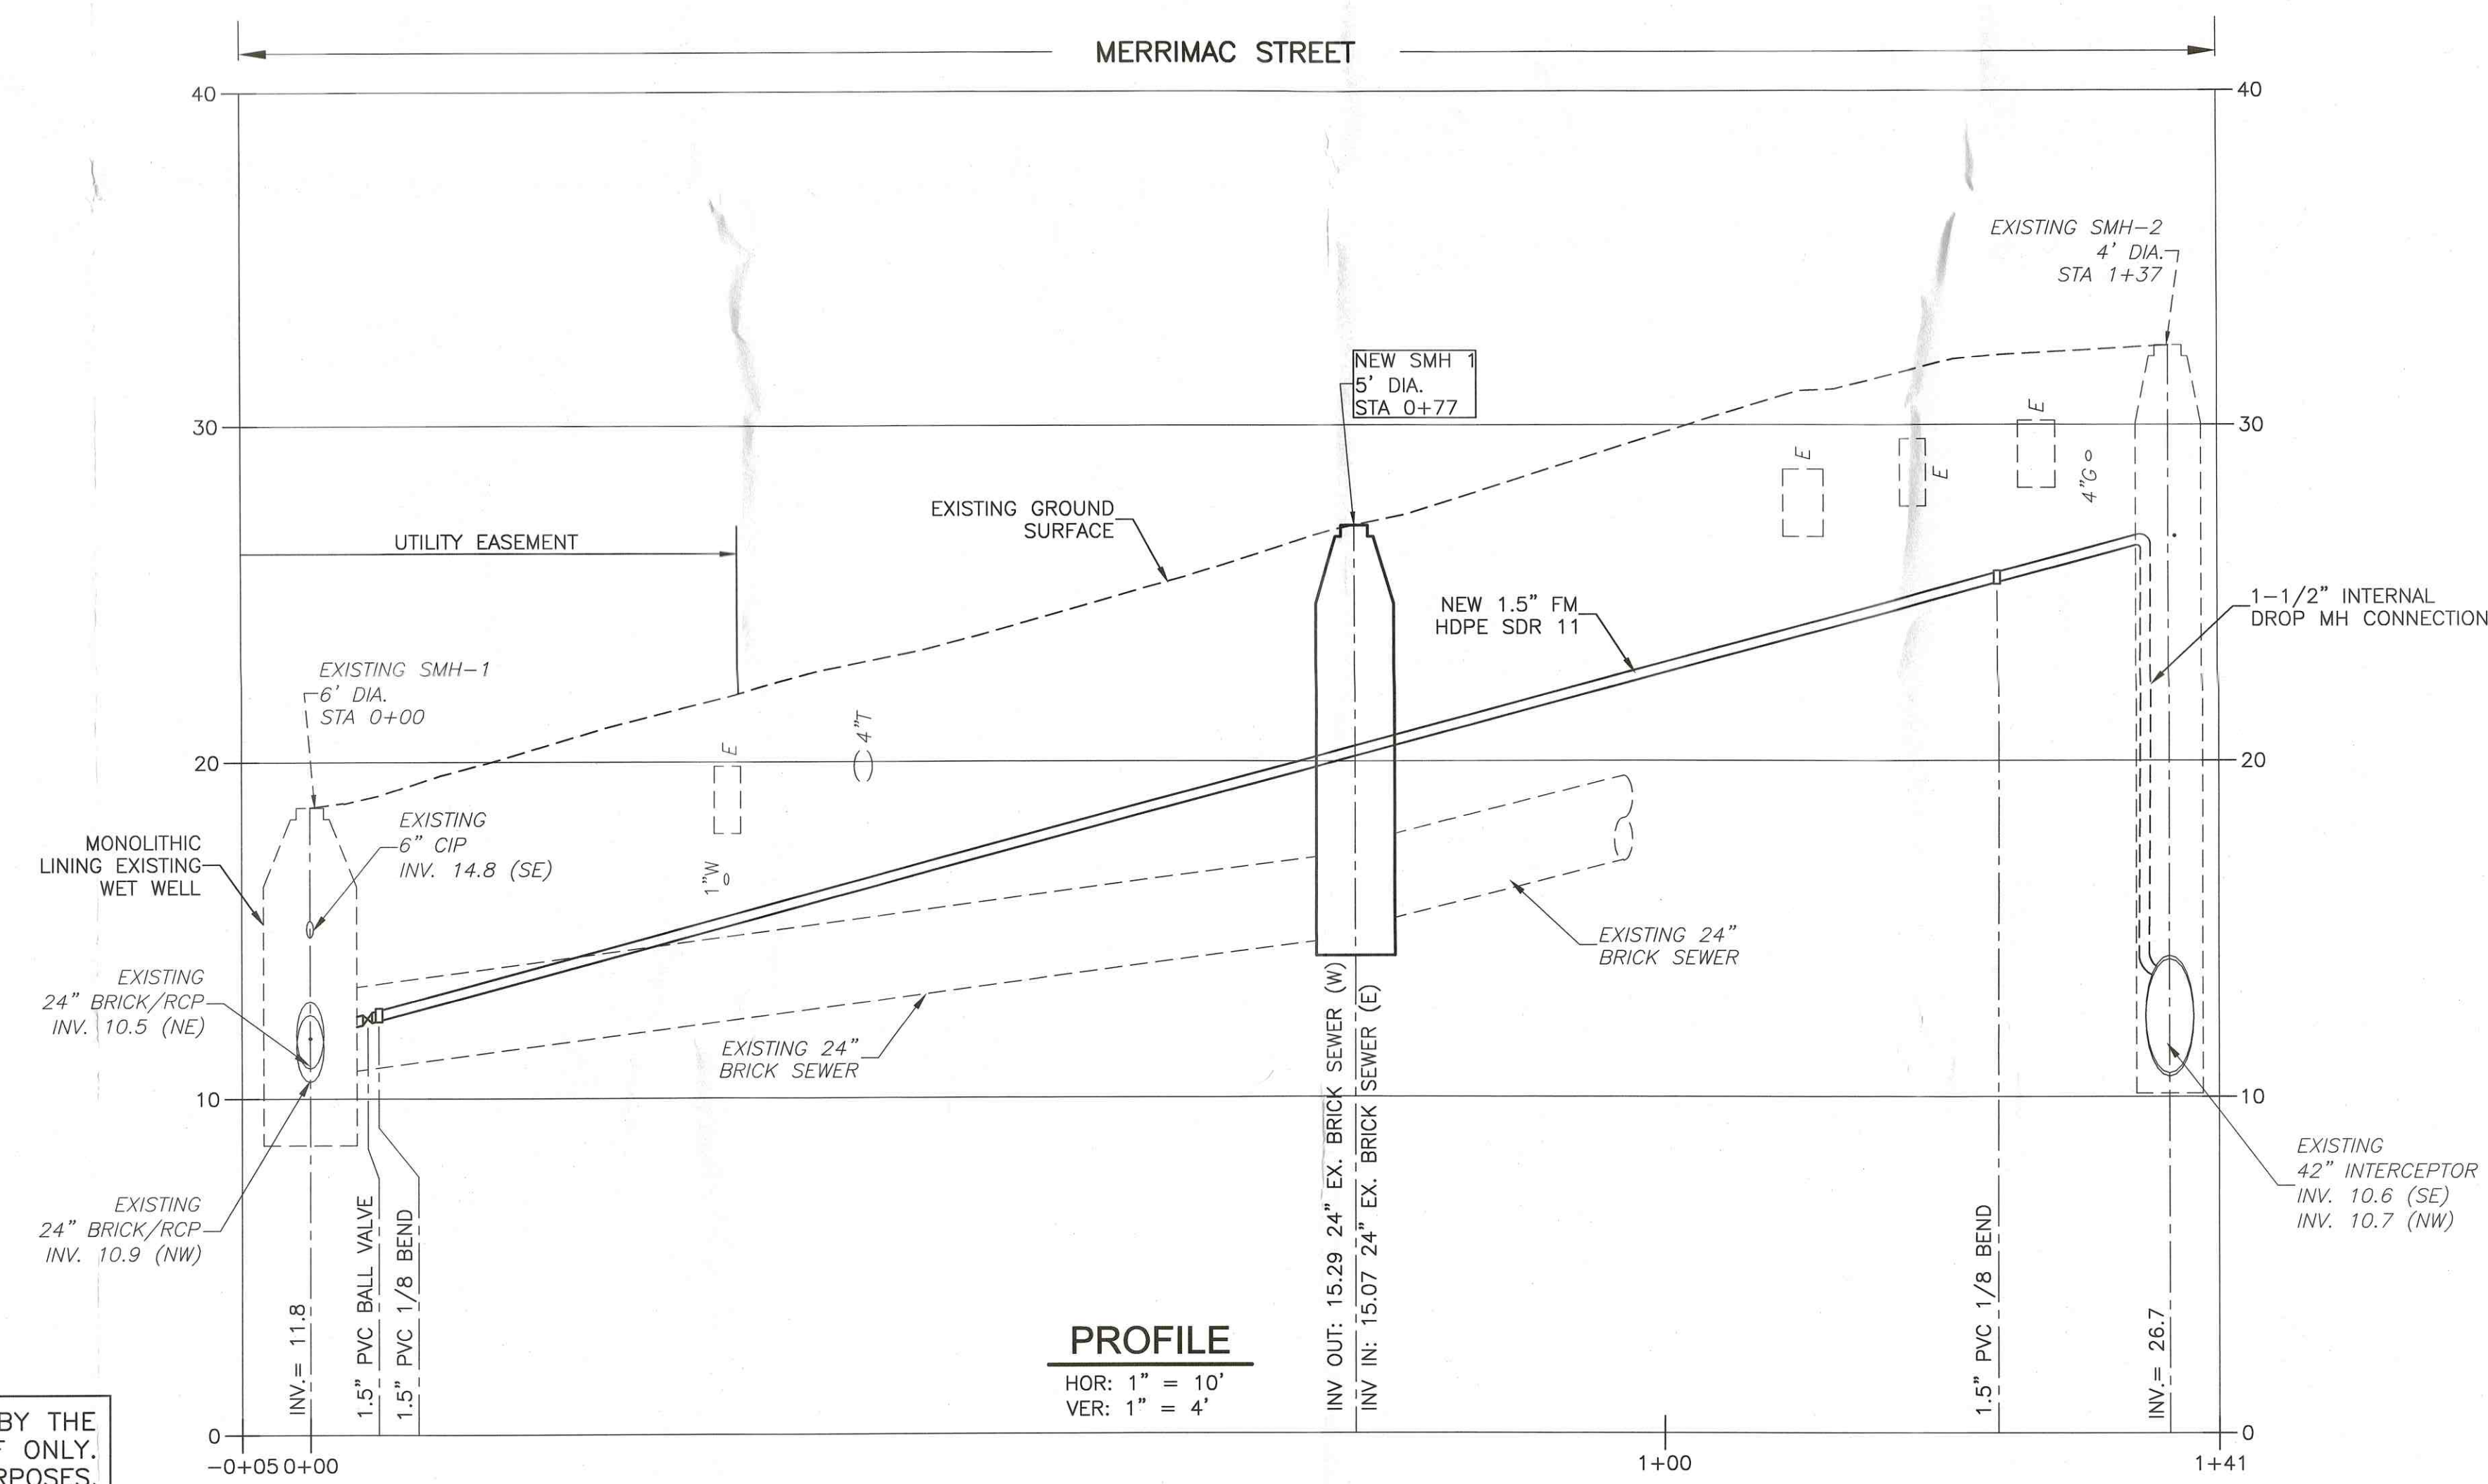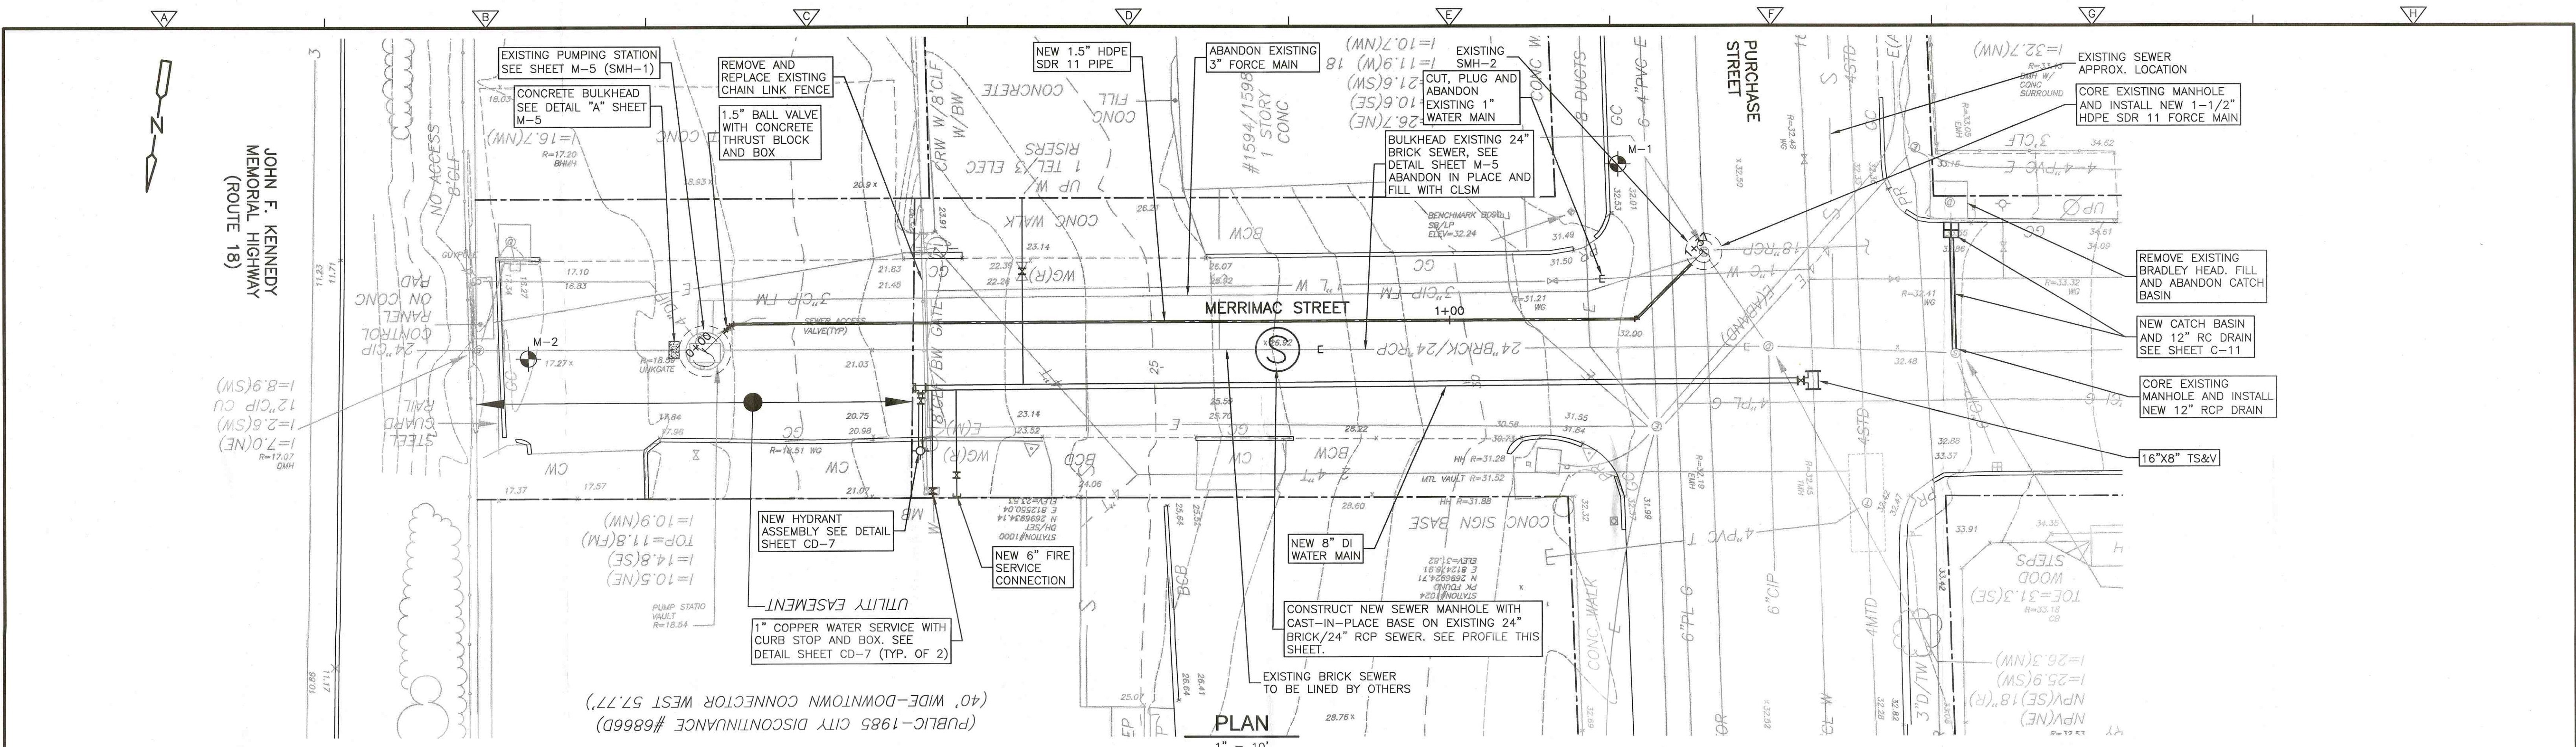

- NOTES:
- SEE SHEETS C-11 THRU C-13 FOR ROADWAY RECONSTRUCTION WORK.
 - SEE APPENDIX A OF VOLUME 3 OF SPECIFICATIONS FOR BORING LOGS FOR M-1 AND M-2.
 - CONFIRM ALL SEWER SERVICE LOCATIONS VIA INTERNAL CCTV INSPECTION AND DYE TESTING.

UNOFFICIAL CONFORMED CONTRACT DRAWINGS ARE FOR USE BY THE CITY OF NEW BEDFORD DPI CONSTRUCTION MANAGEMENT STAFF ONLY. THESE DRAWINGS ARE PROVIDED SOLELY FOR INFORMATIONAL PURPOSES.

REV. NO.	DATE	DRWN	CHKD	REMARKS
2	9/18	AW	JH	CONFORMED DRAWING
1	4/26/18	JJC	S.T.S.	CALL OUT REVISION

DESIGNED BY:	S. SYDE
DRAWN BY:	J. CABRERA
SHEET CHK'D BY:	S. SYDE
CROSS CHK'D BY:	R. NORTON
APPROVED BY:	S. SYDE
DATE:	MARCH 2018

CDM Smith
280 West Exchange Street, Suite 300
Providence, RI 02903
Tel: (401) 751-5360

CITY OF NEW BEDFORD, MASSACHUSETTS
WASTEWATER SYSTEM IMPROVEMENTS
FRONT STREET PUMPING STATION AND
MERRIMAC STREET PUMPING STATION
REHABILITATION PROJECT

MERRIMAC STREET PUMPING STATION
GENERAL PLAN AND PROFILE

PROJECT NO.	0309-219437
FILE NAME:	C010PSPL.DWG
SHEET NO.	C-10

CONFORMED DRAWING